




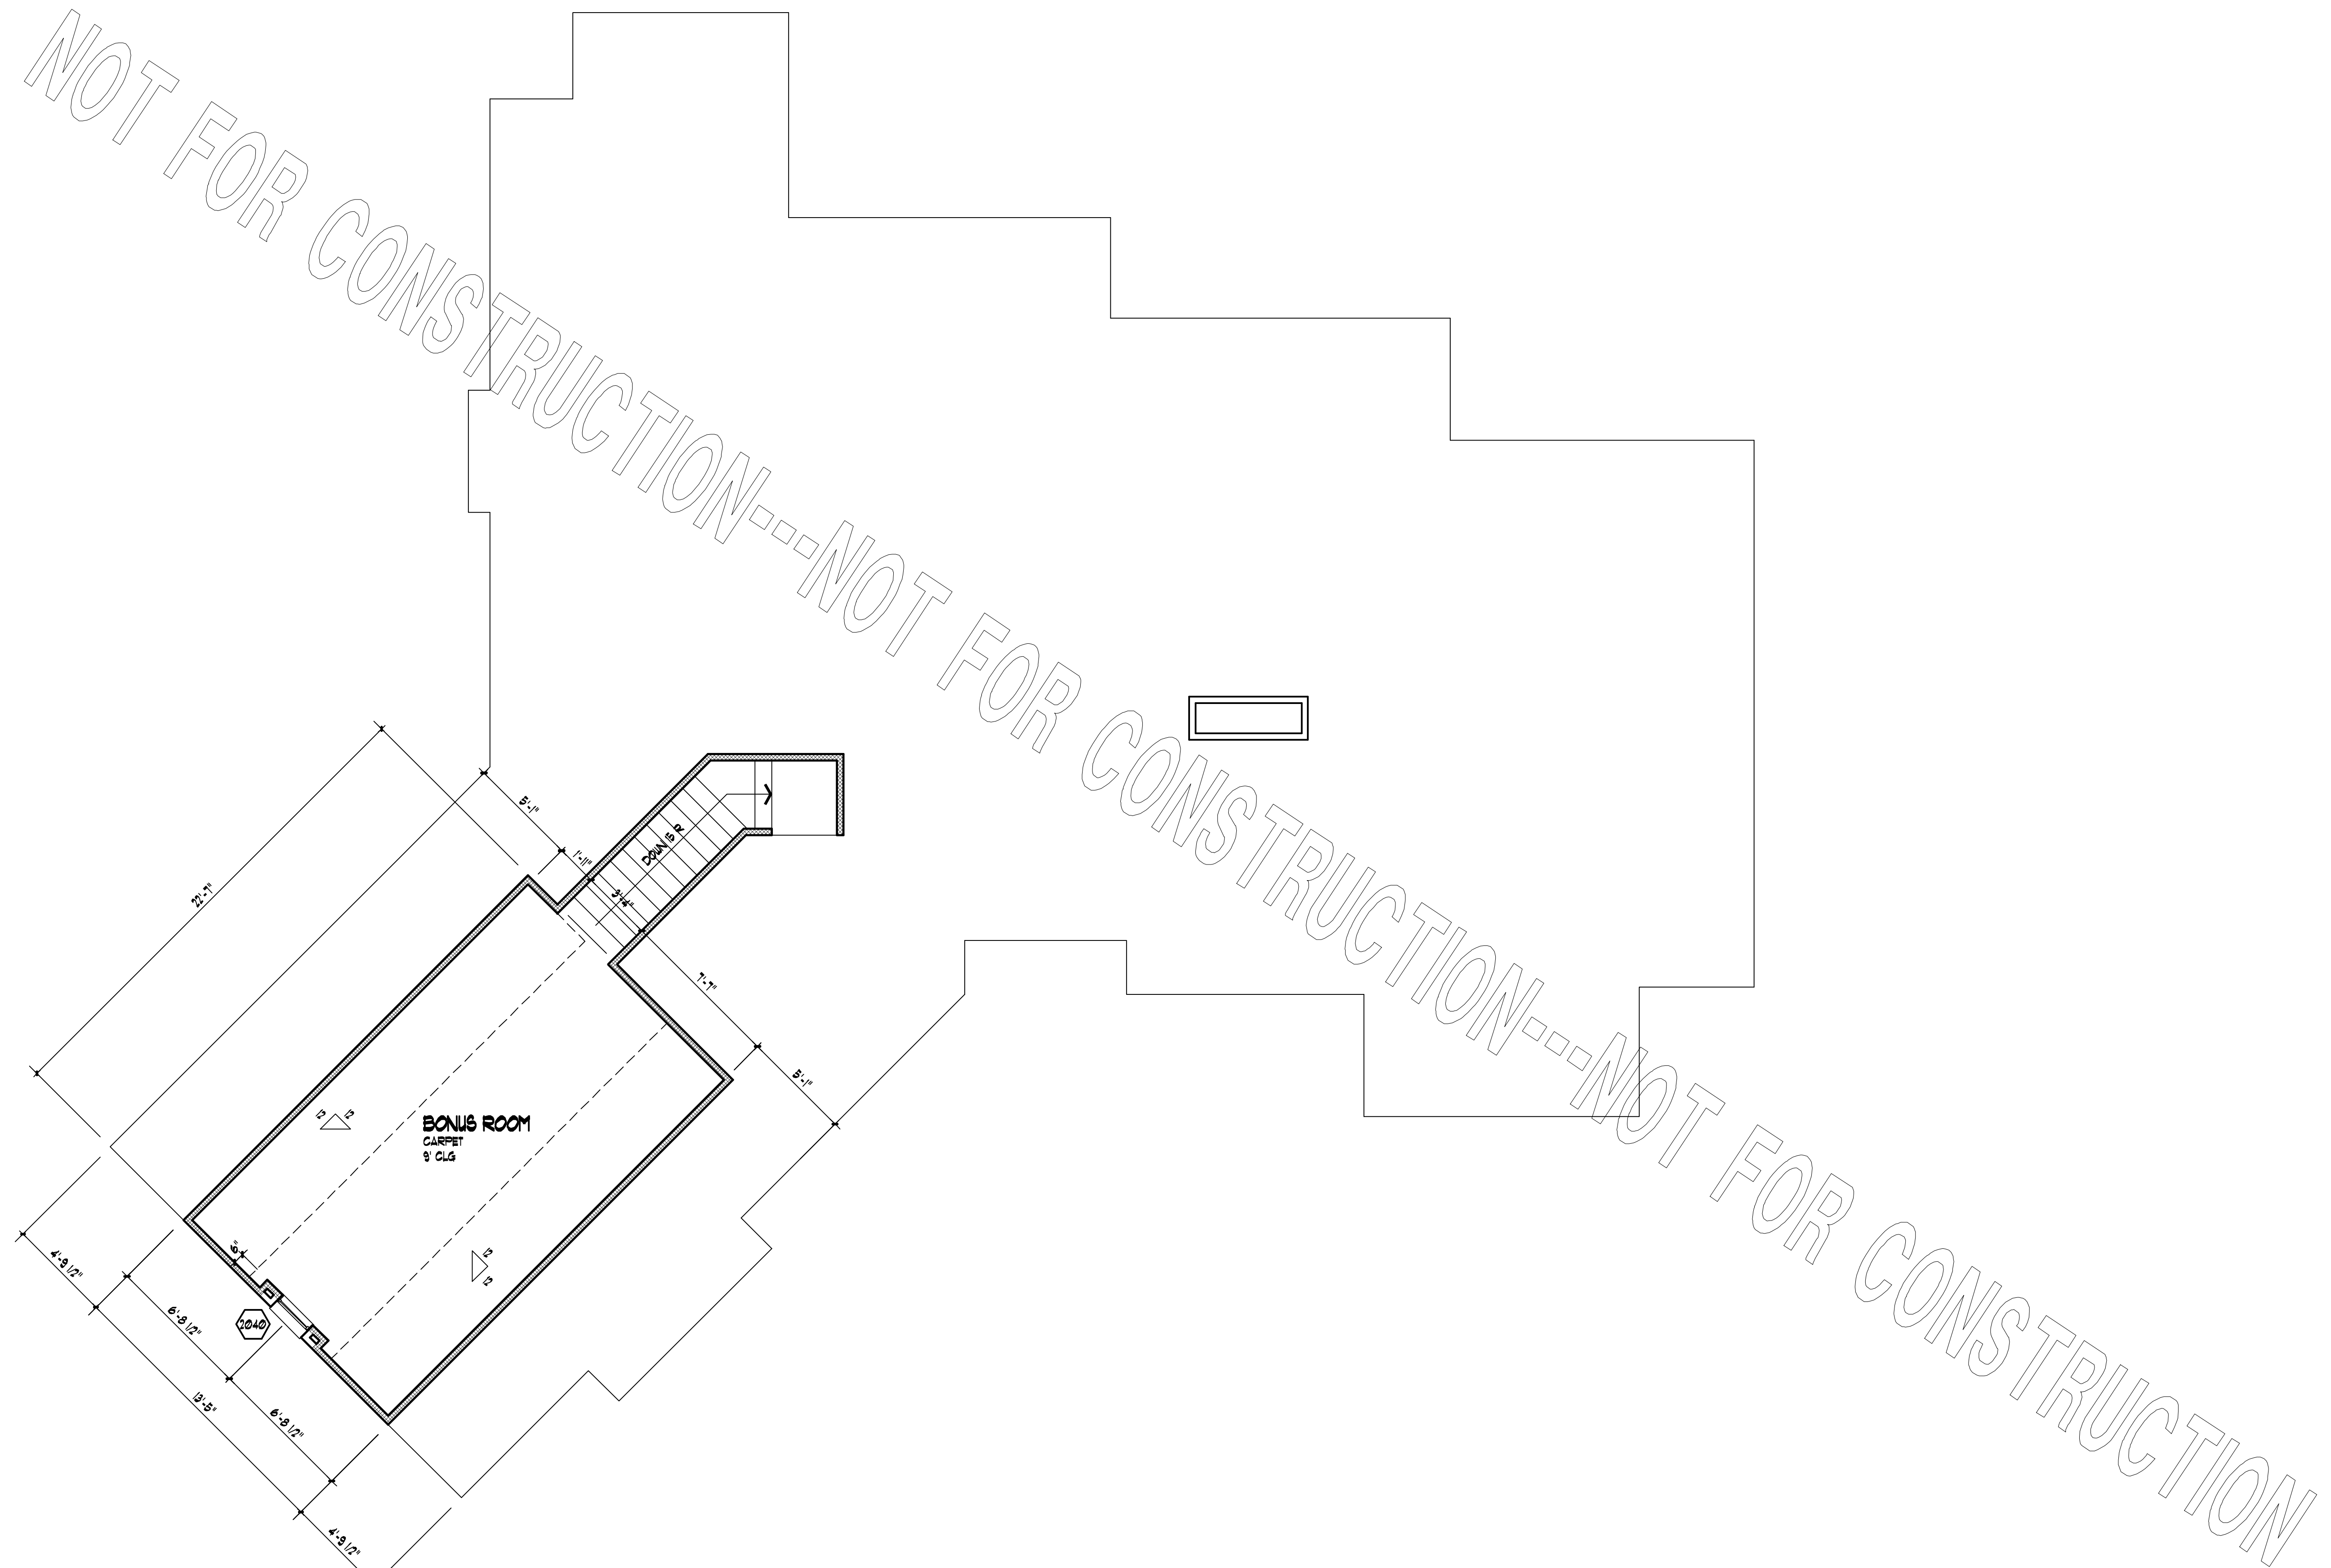


SECOND FLOOR PLAN
SCALE: 1/4" = 1'-0"

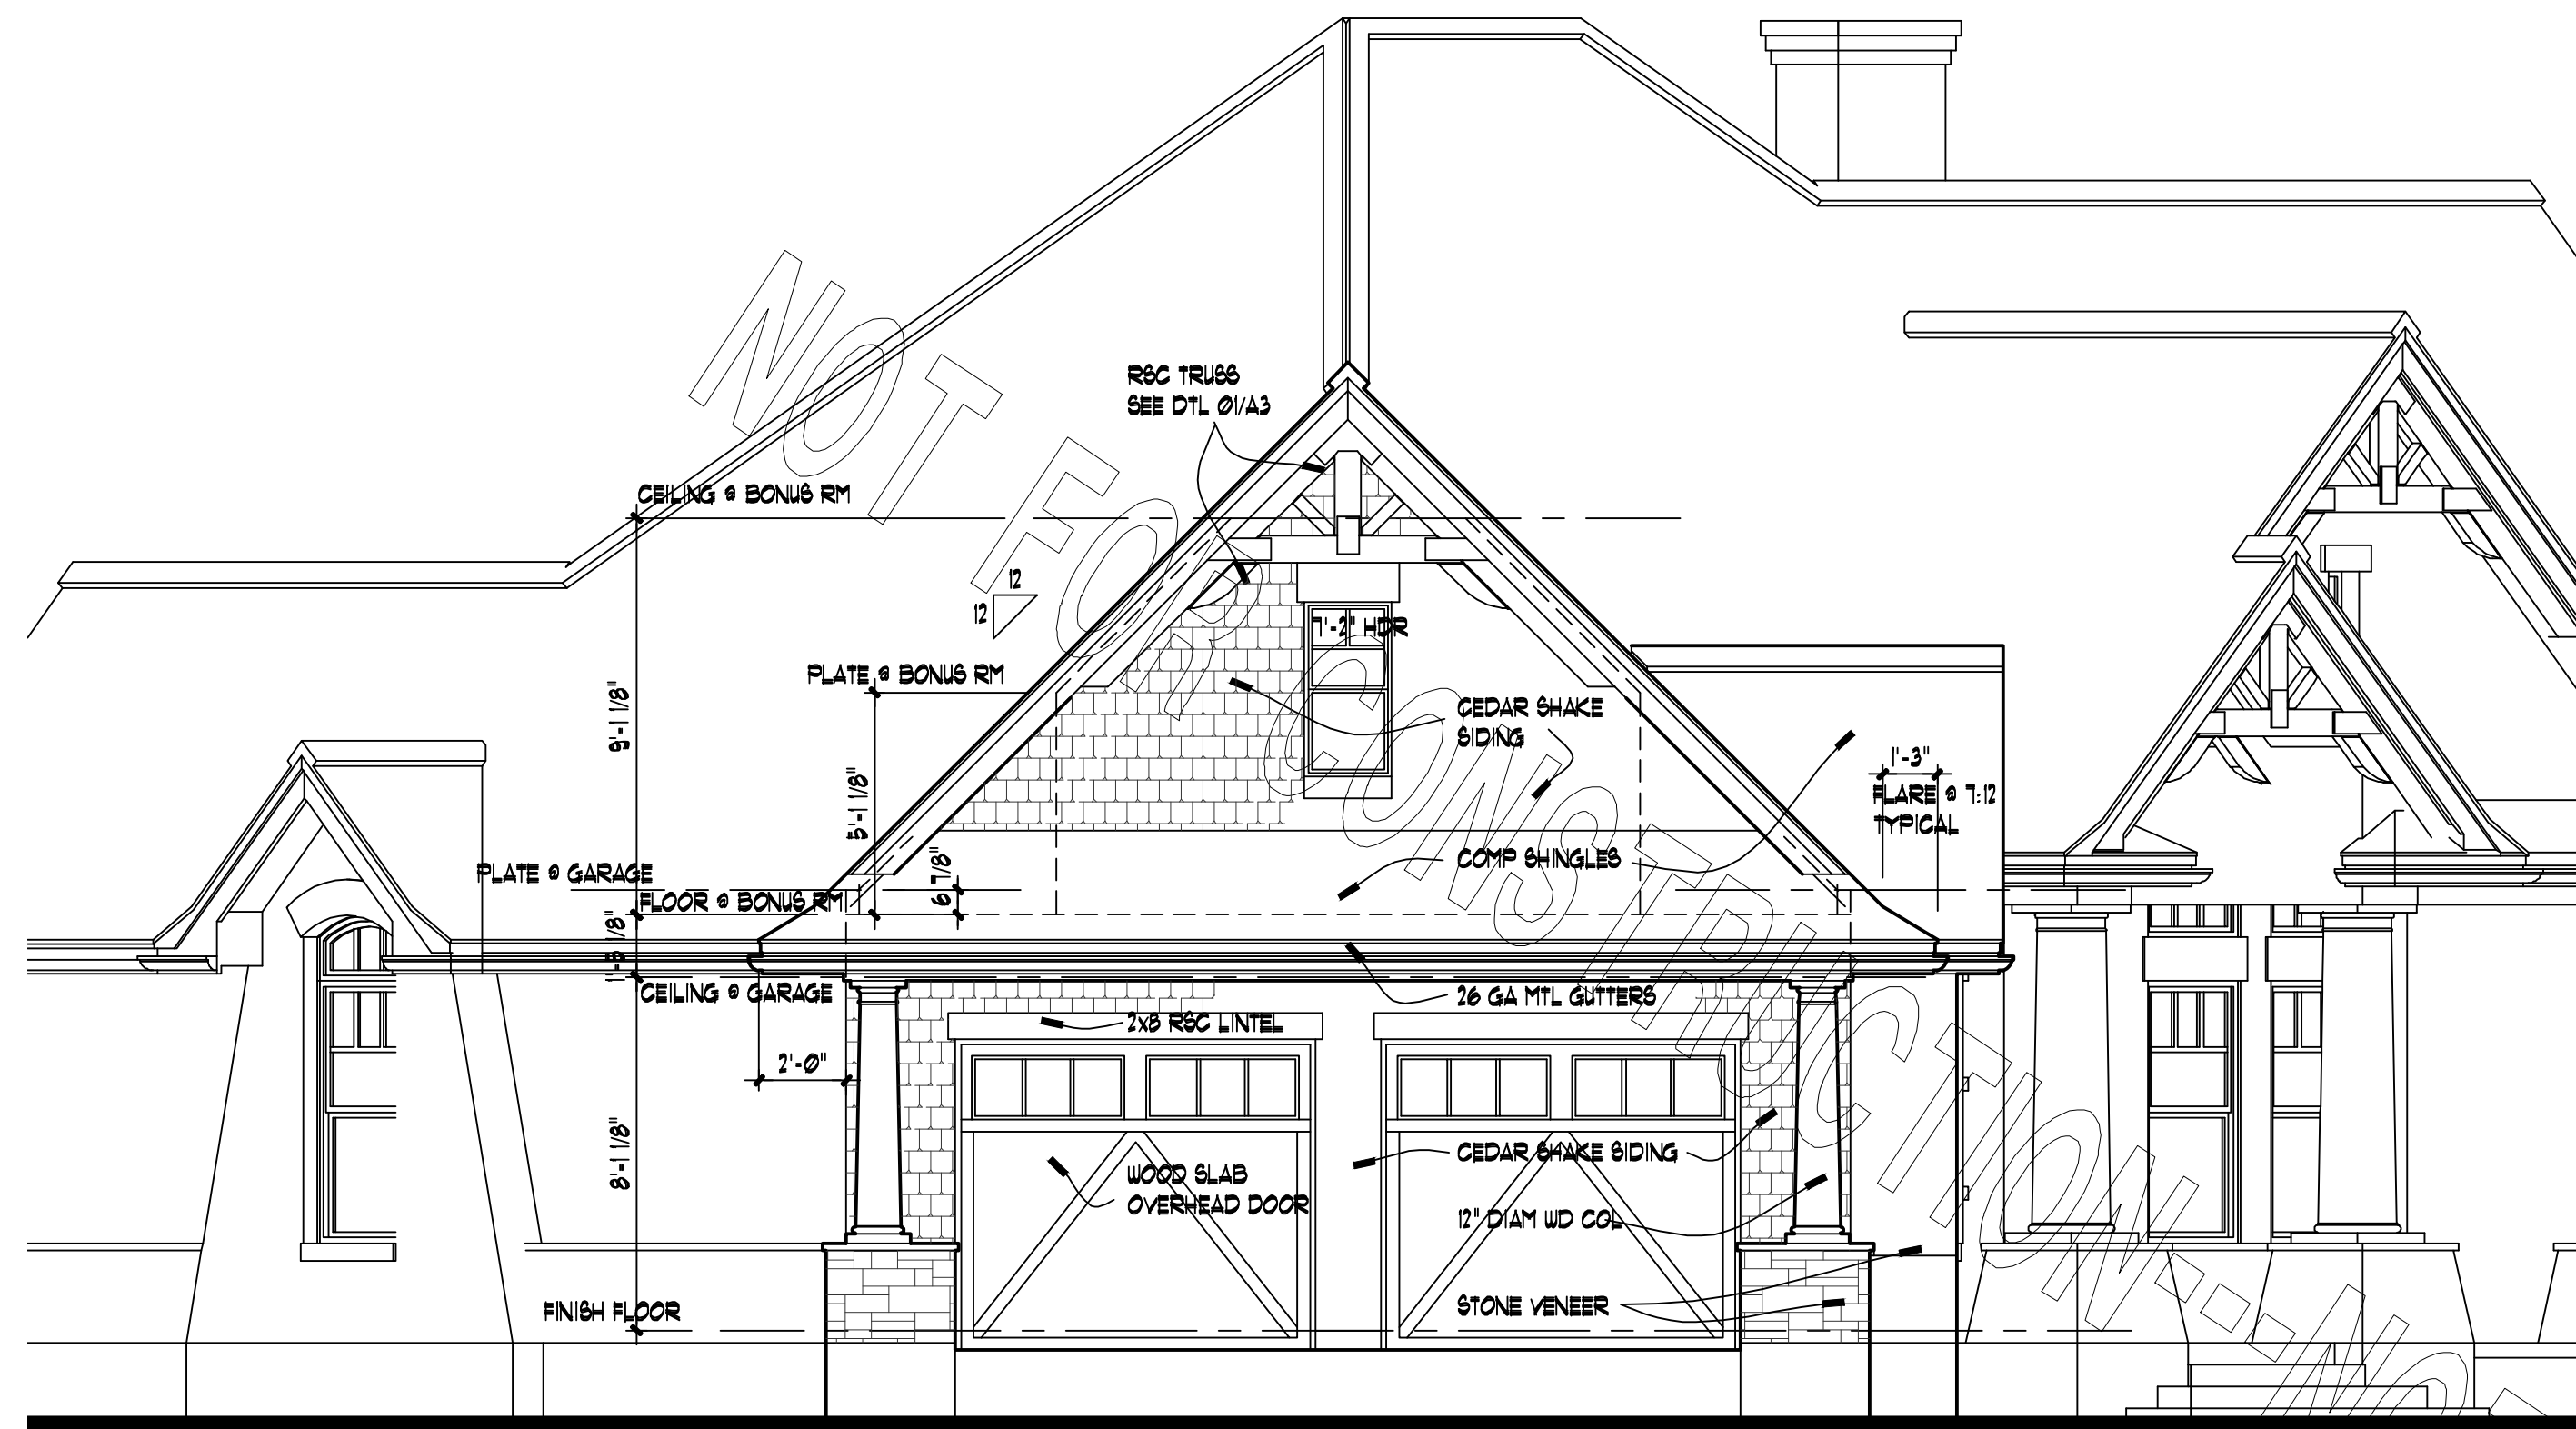


PARTIAL LEFT ELEVATION
SCALE: 1/4" = 1'-0"

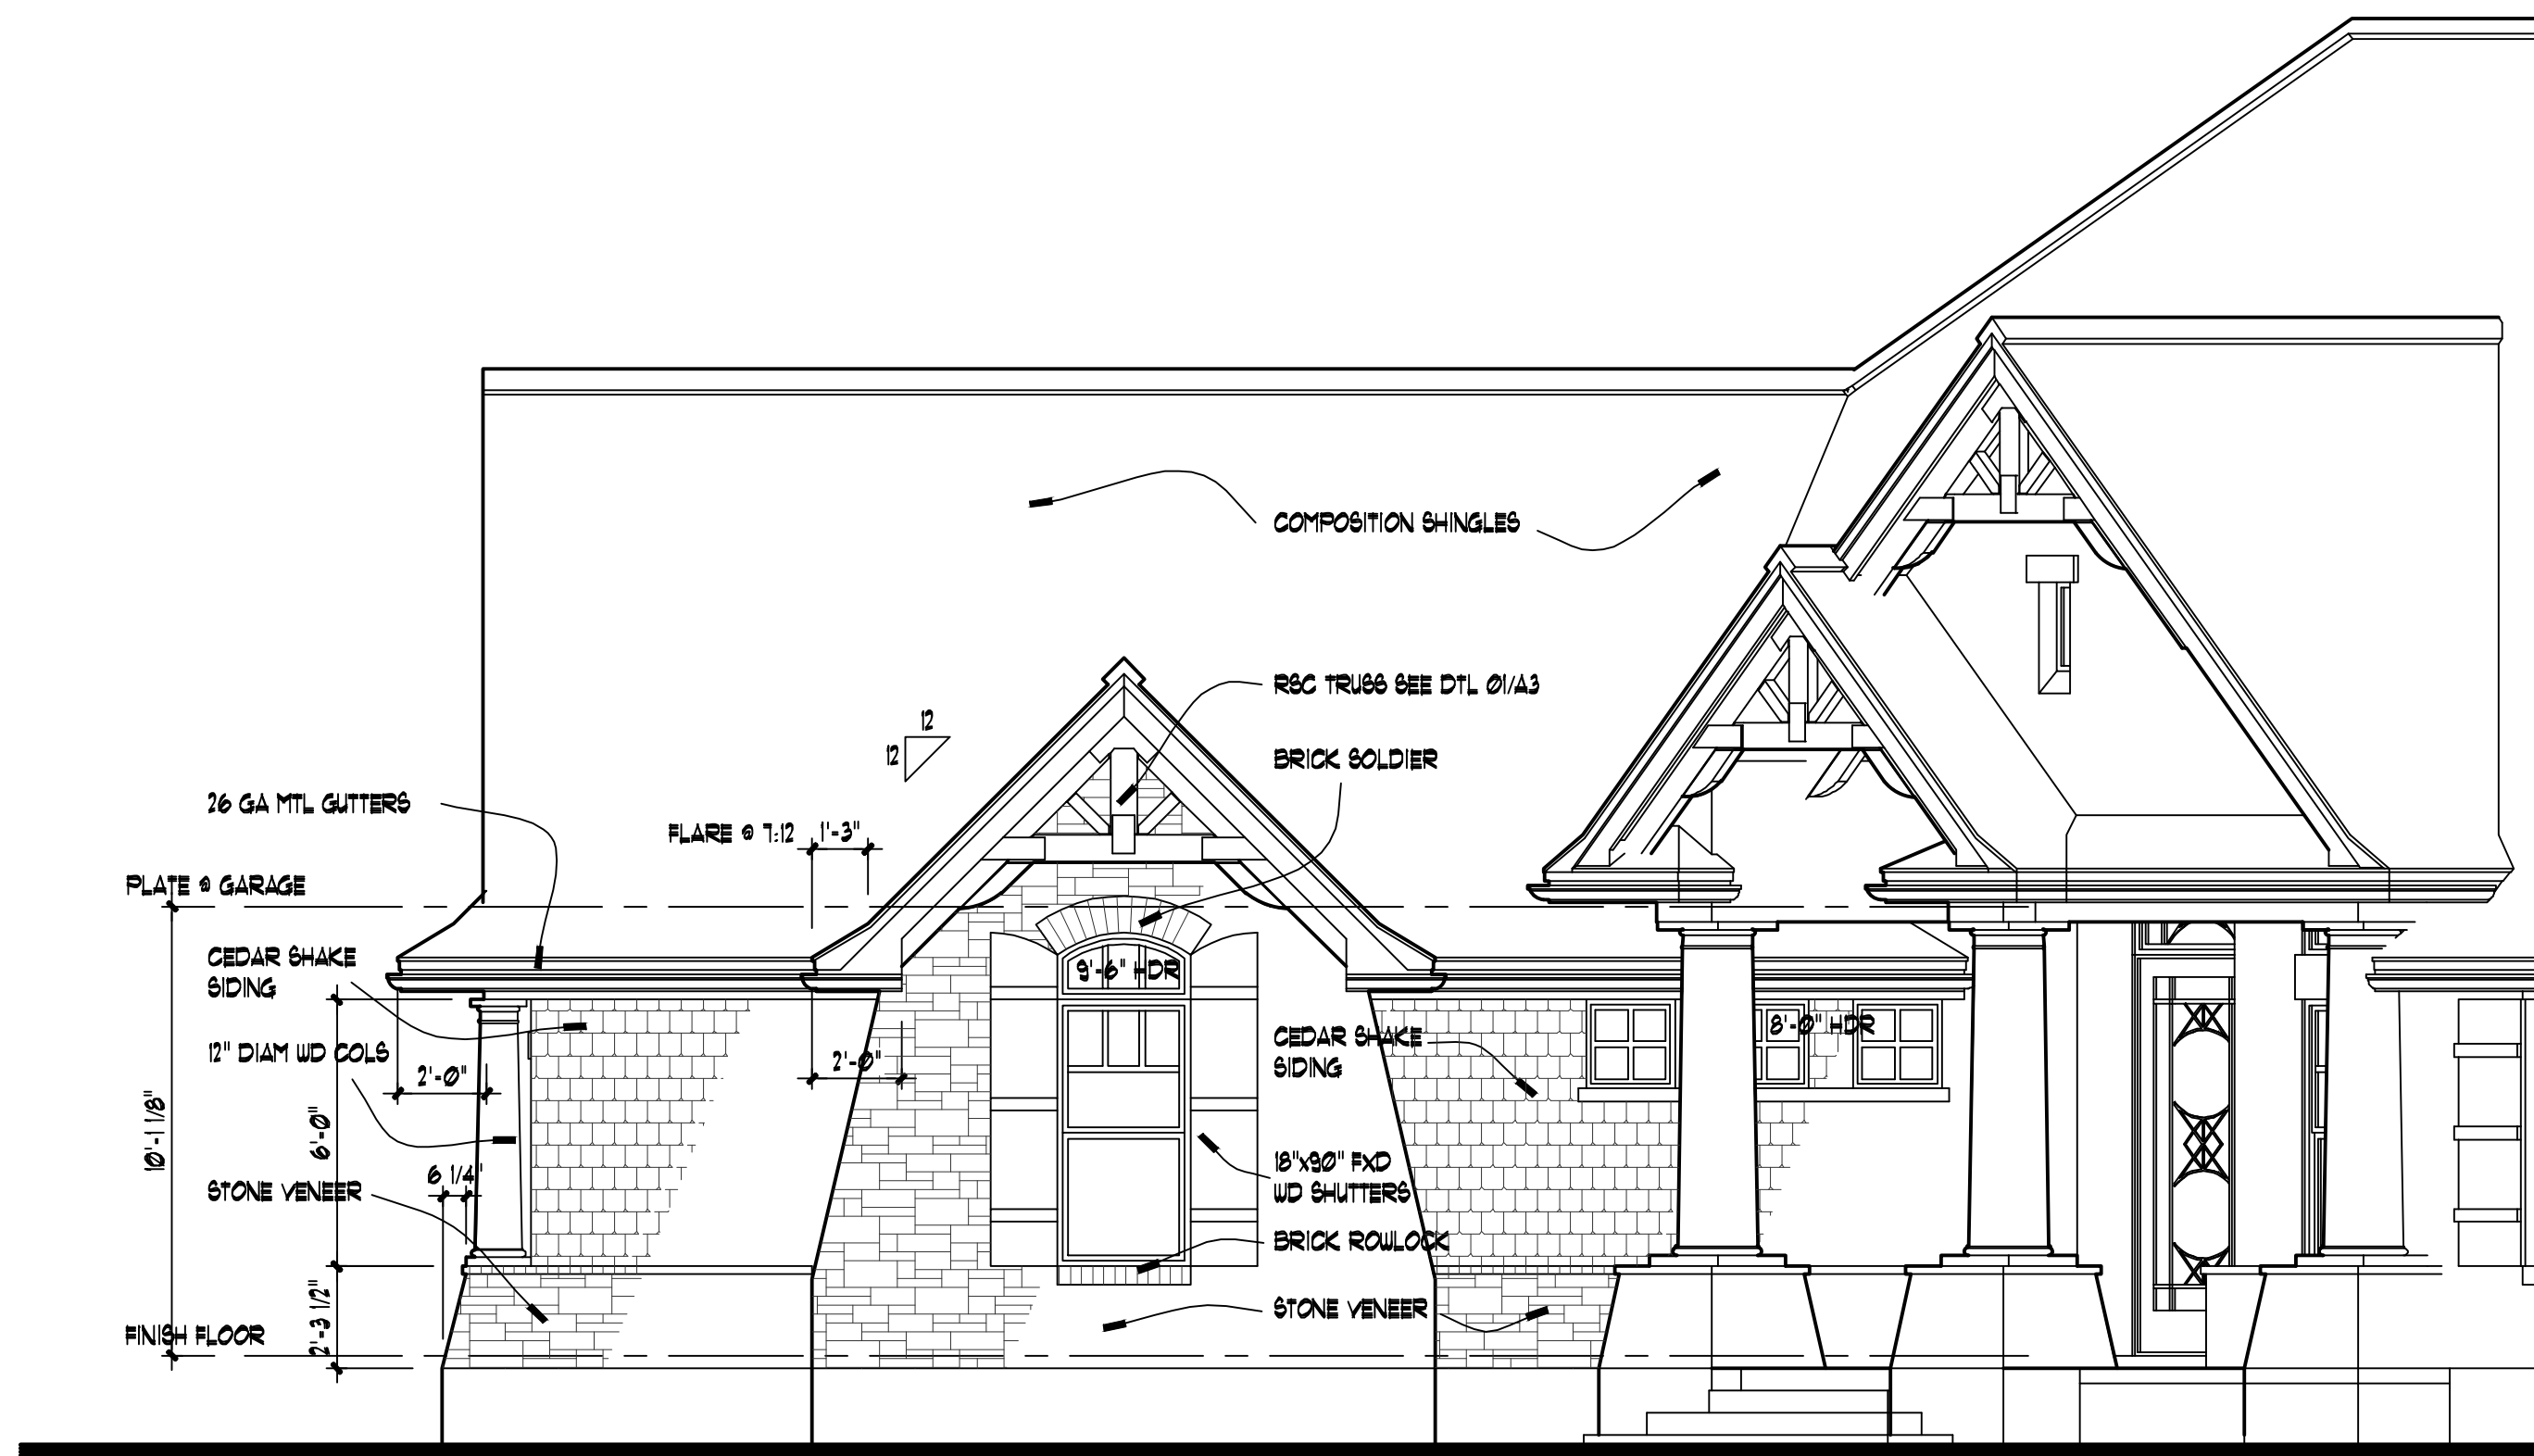


PARTIAL FRONT ELEVATION
SCALE: 1/4" = 1'-0"

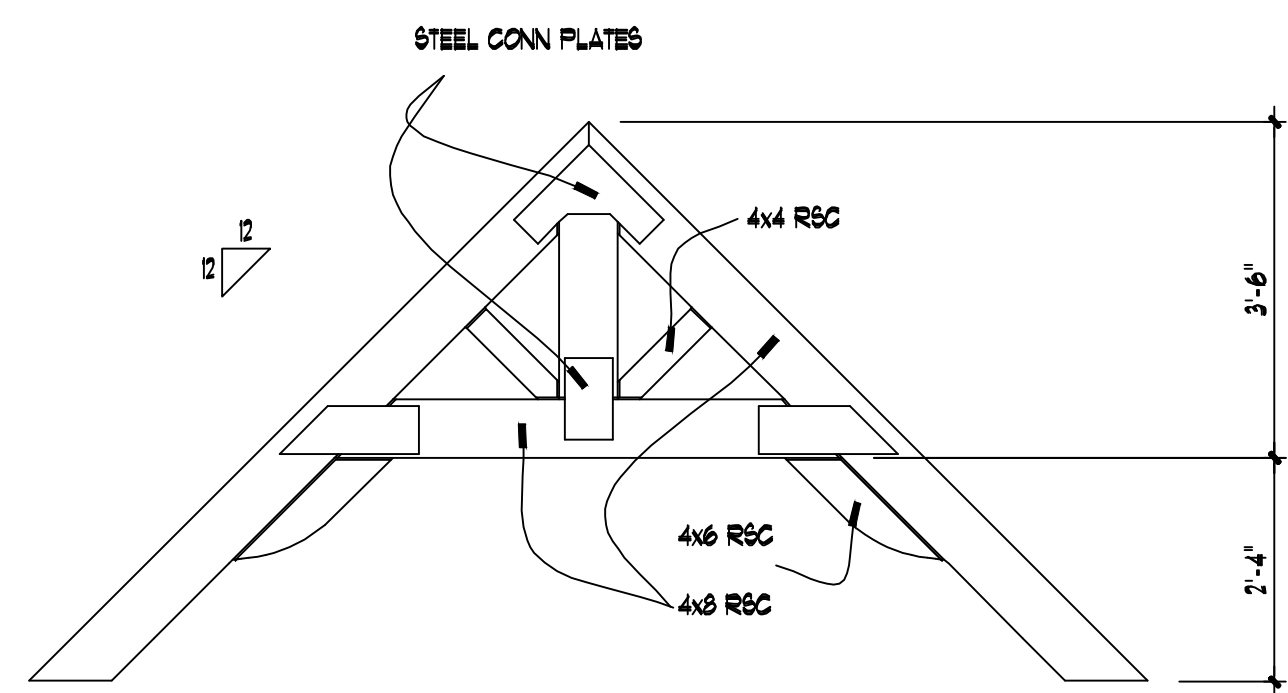

TRUSS DETAIL
3/8" = 1'-0"

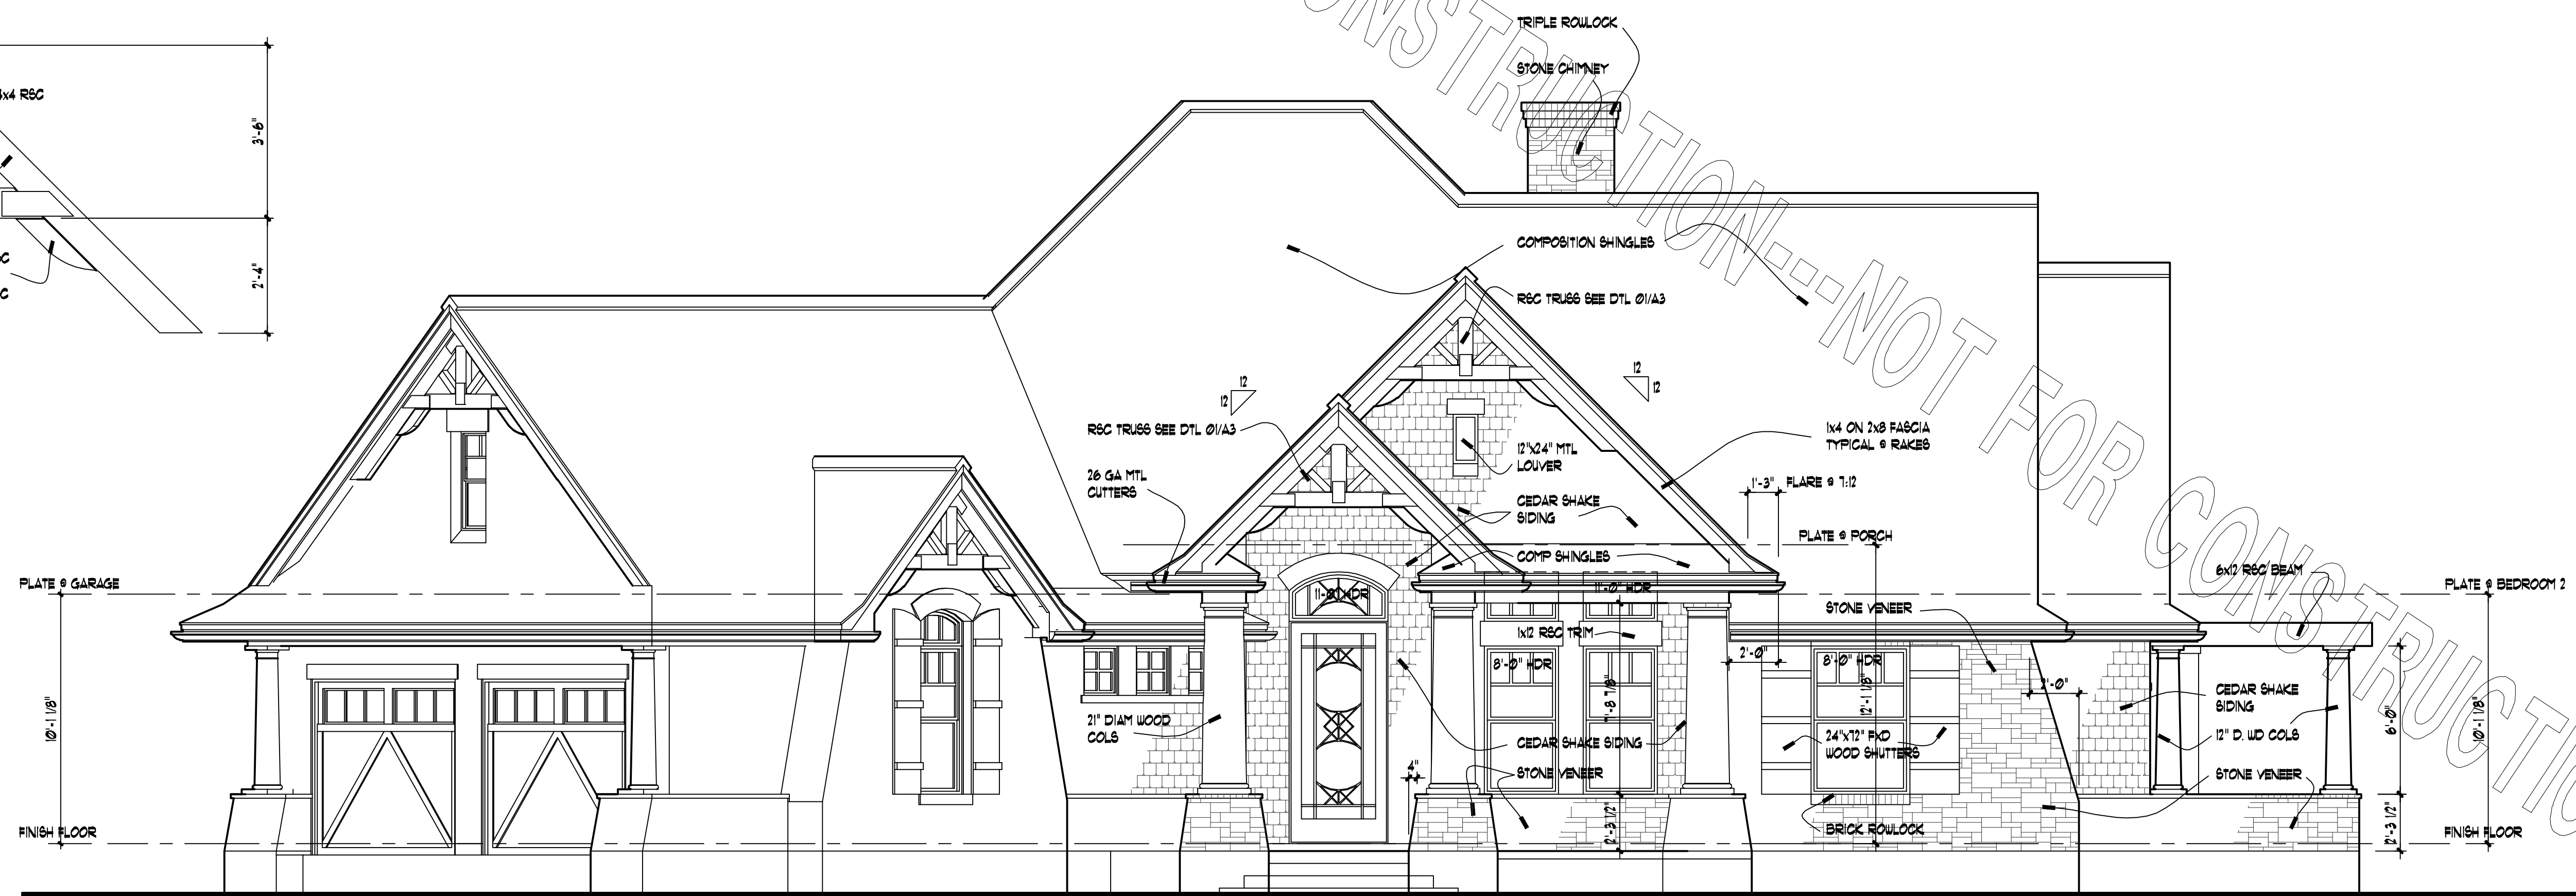


FRONT ELEVATION
SCALE: 1/4" = 1'-0"

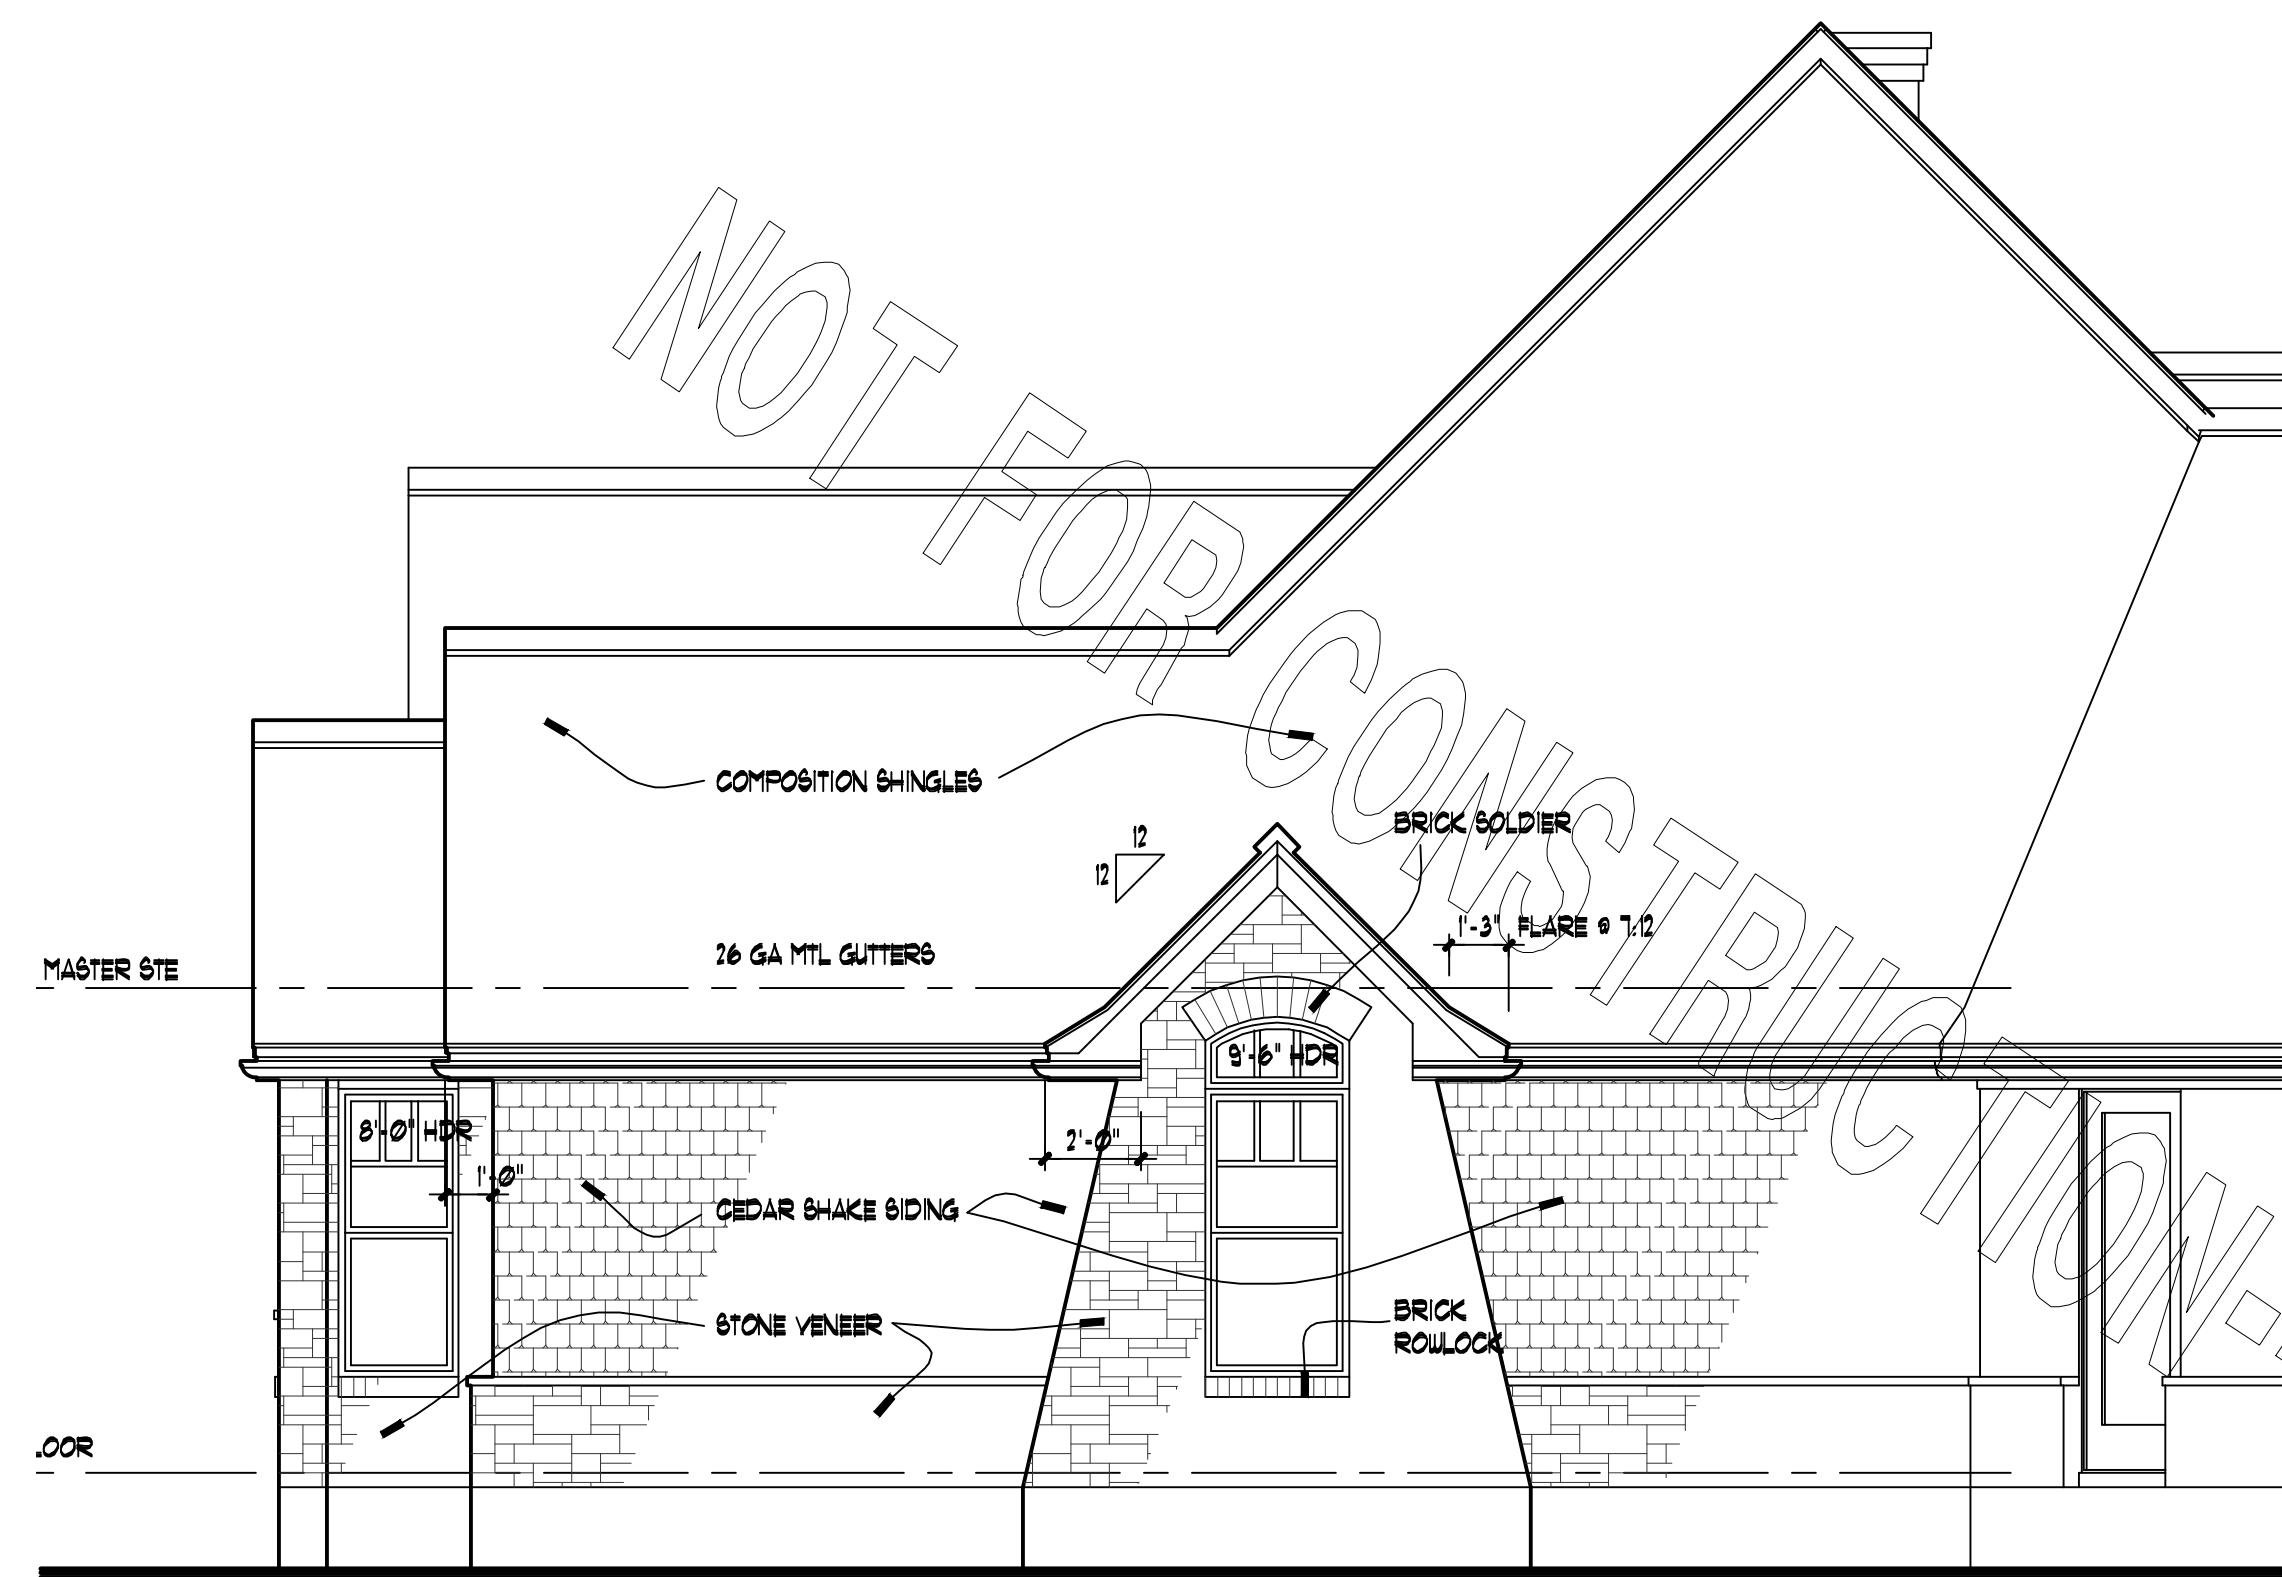


PARTIAL LEFT ELEVATION

SCALE: 1/4" = 1'-0"

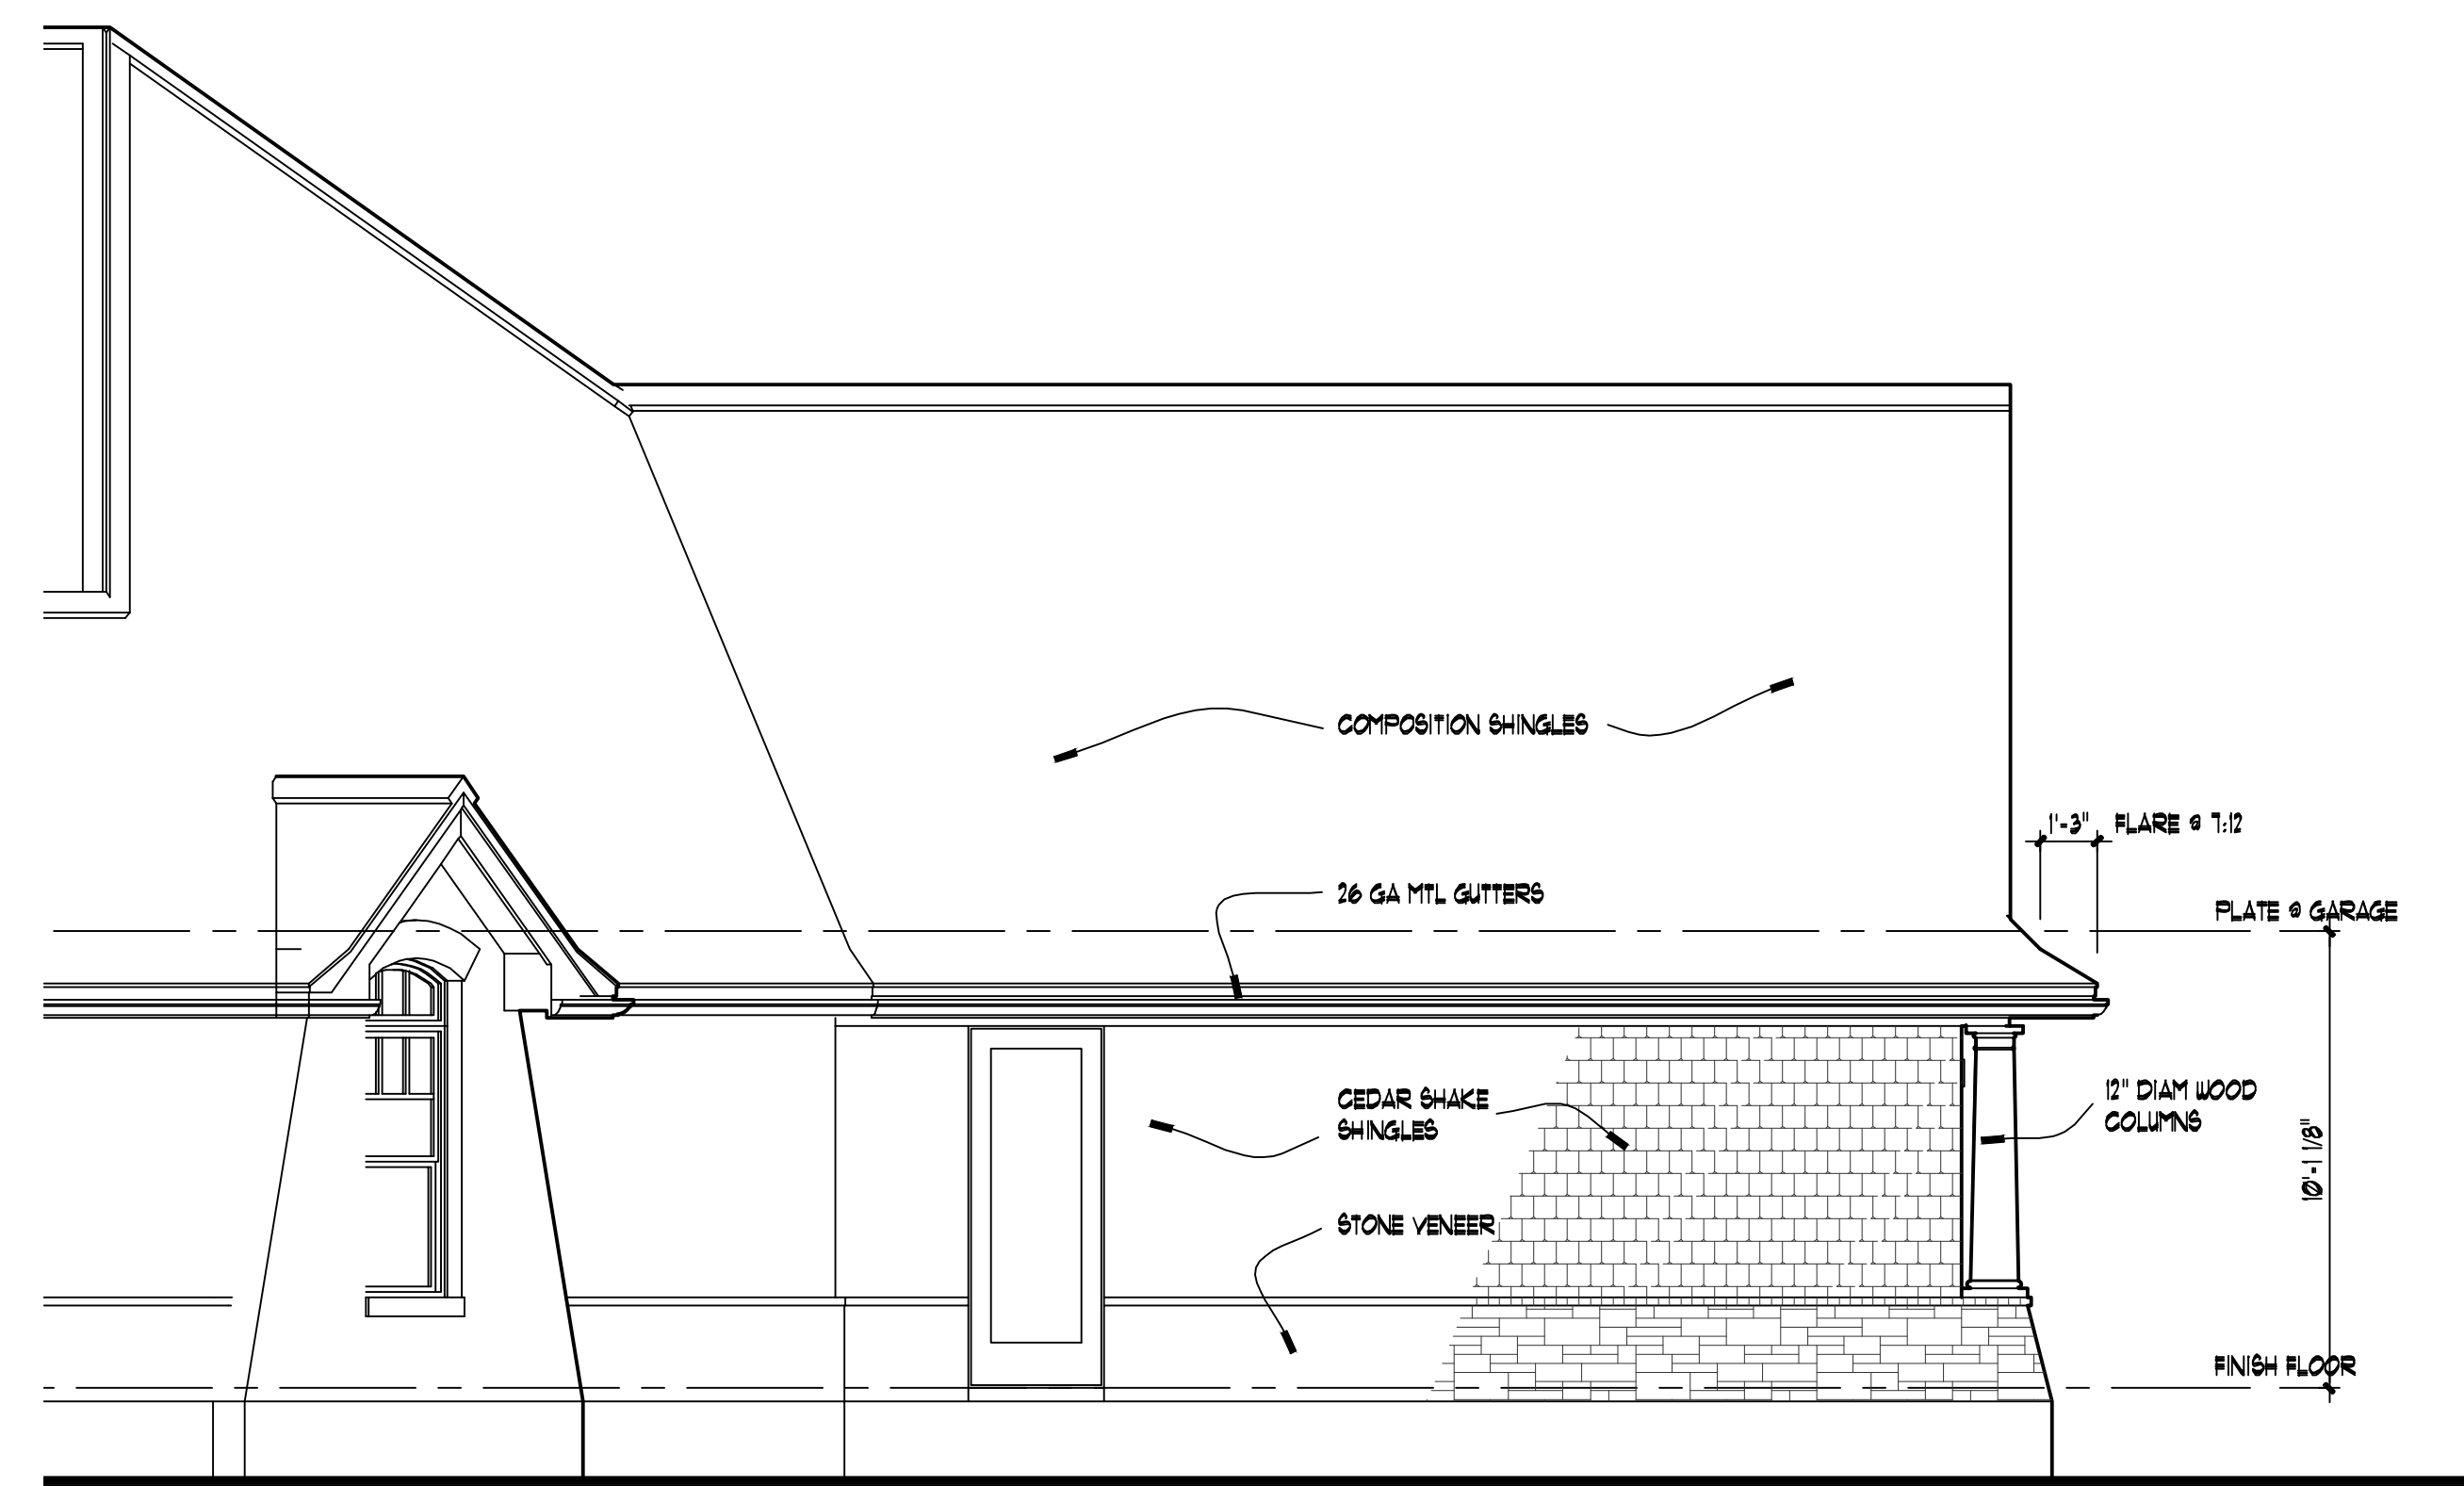


PARTIAL REAR ELEVATION

SCALE: 1/4" = 1'-0"

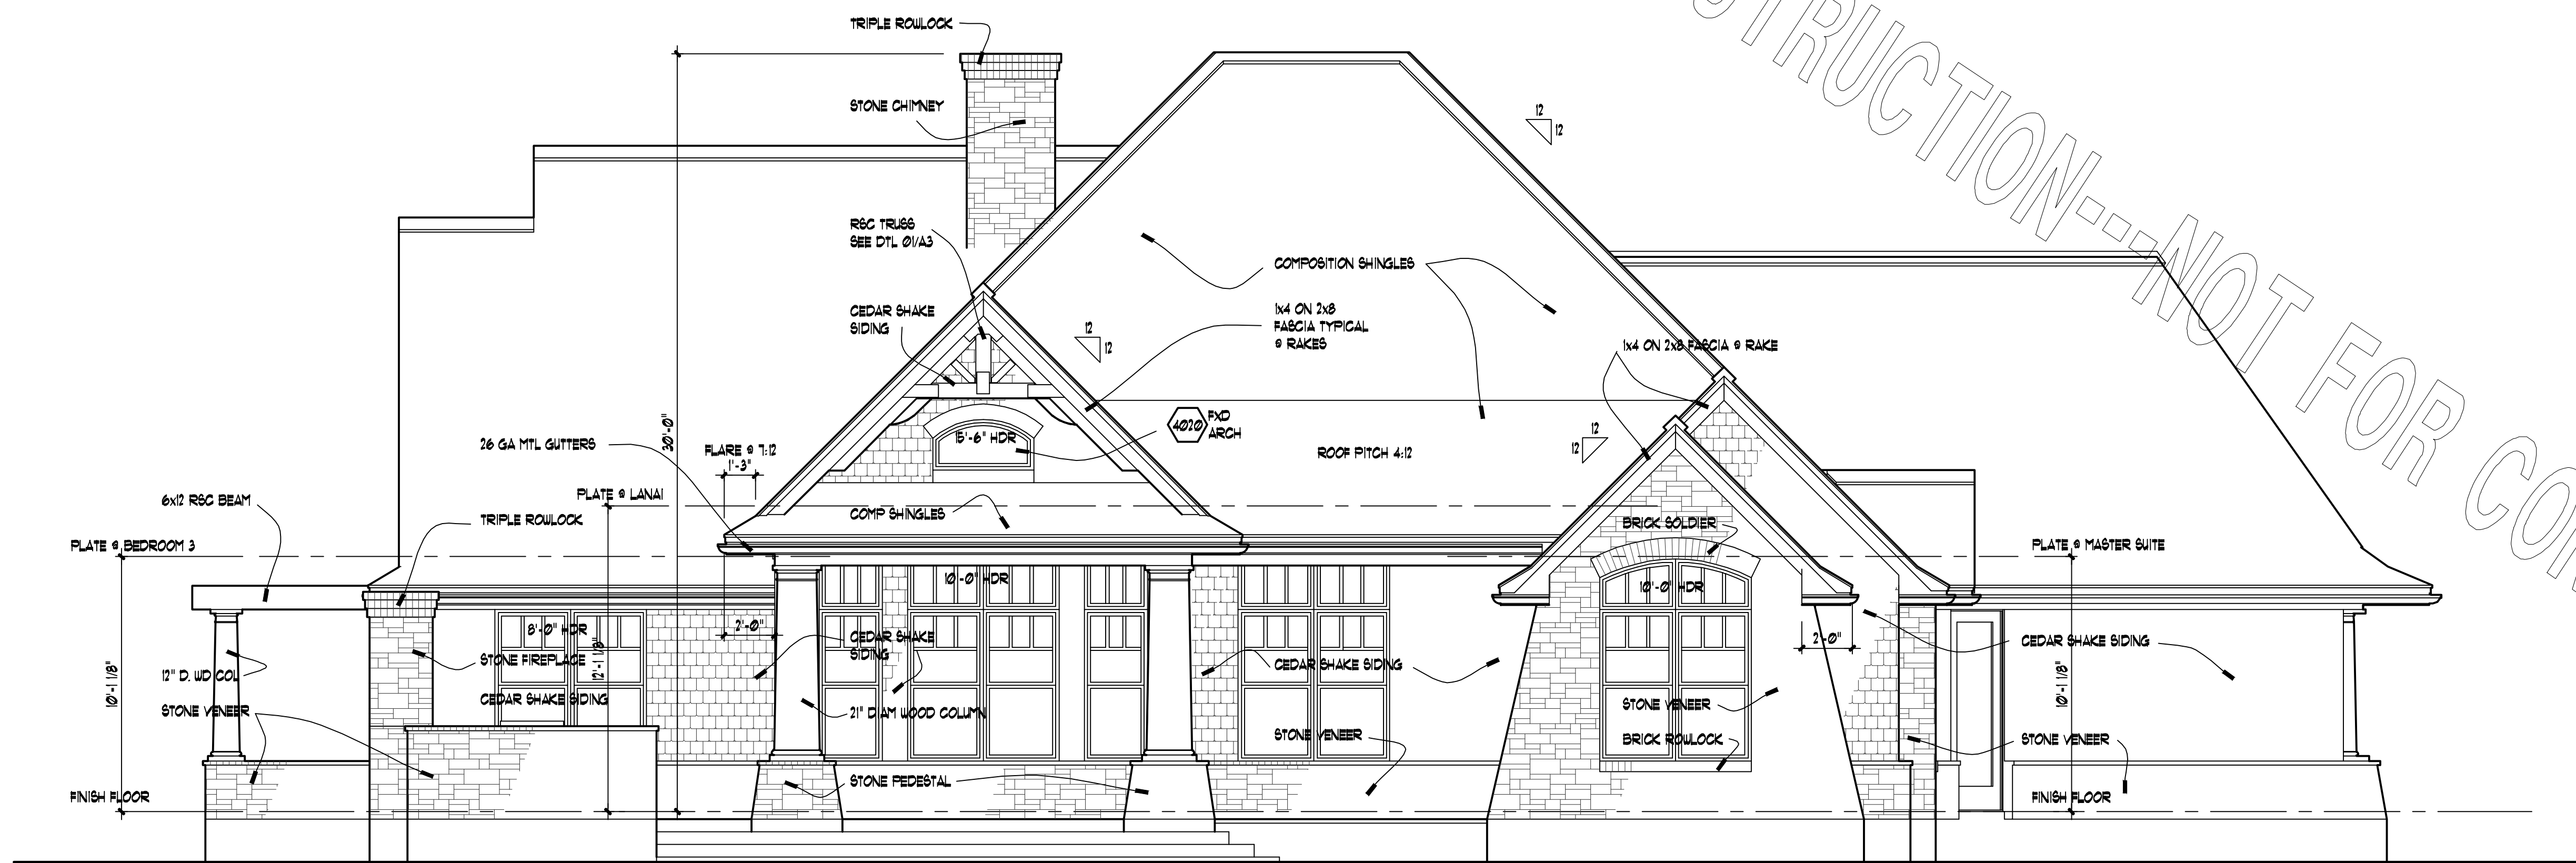


REAR ELEVATION

SCALE: 1/4" = 1'-0"

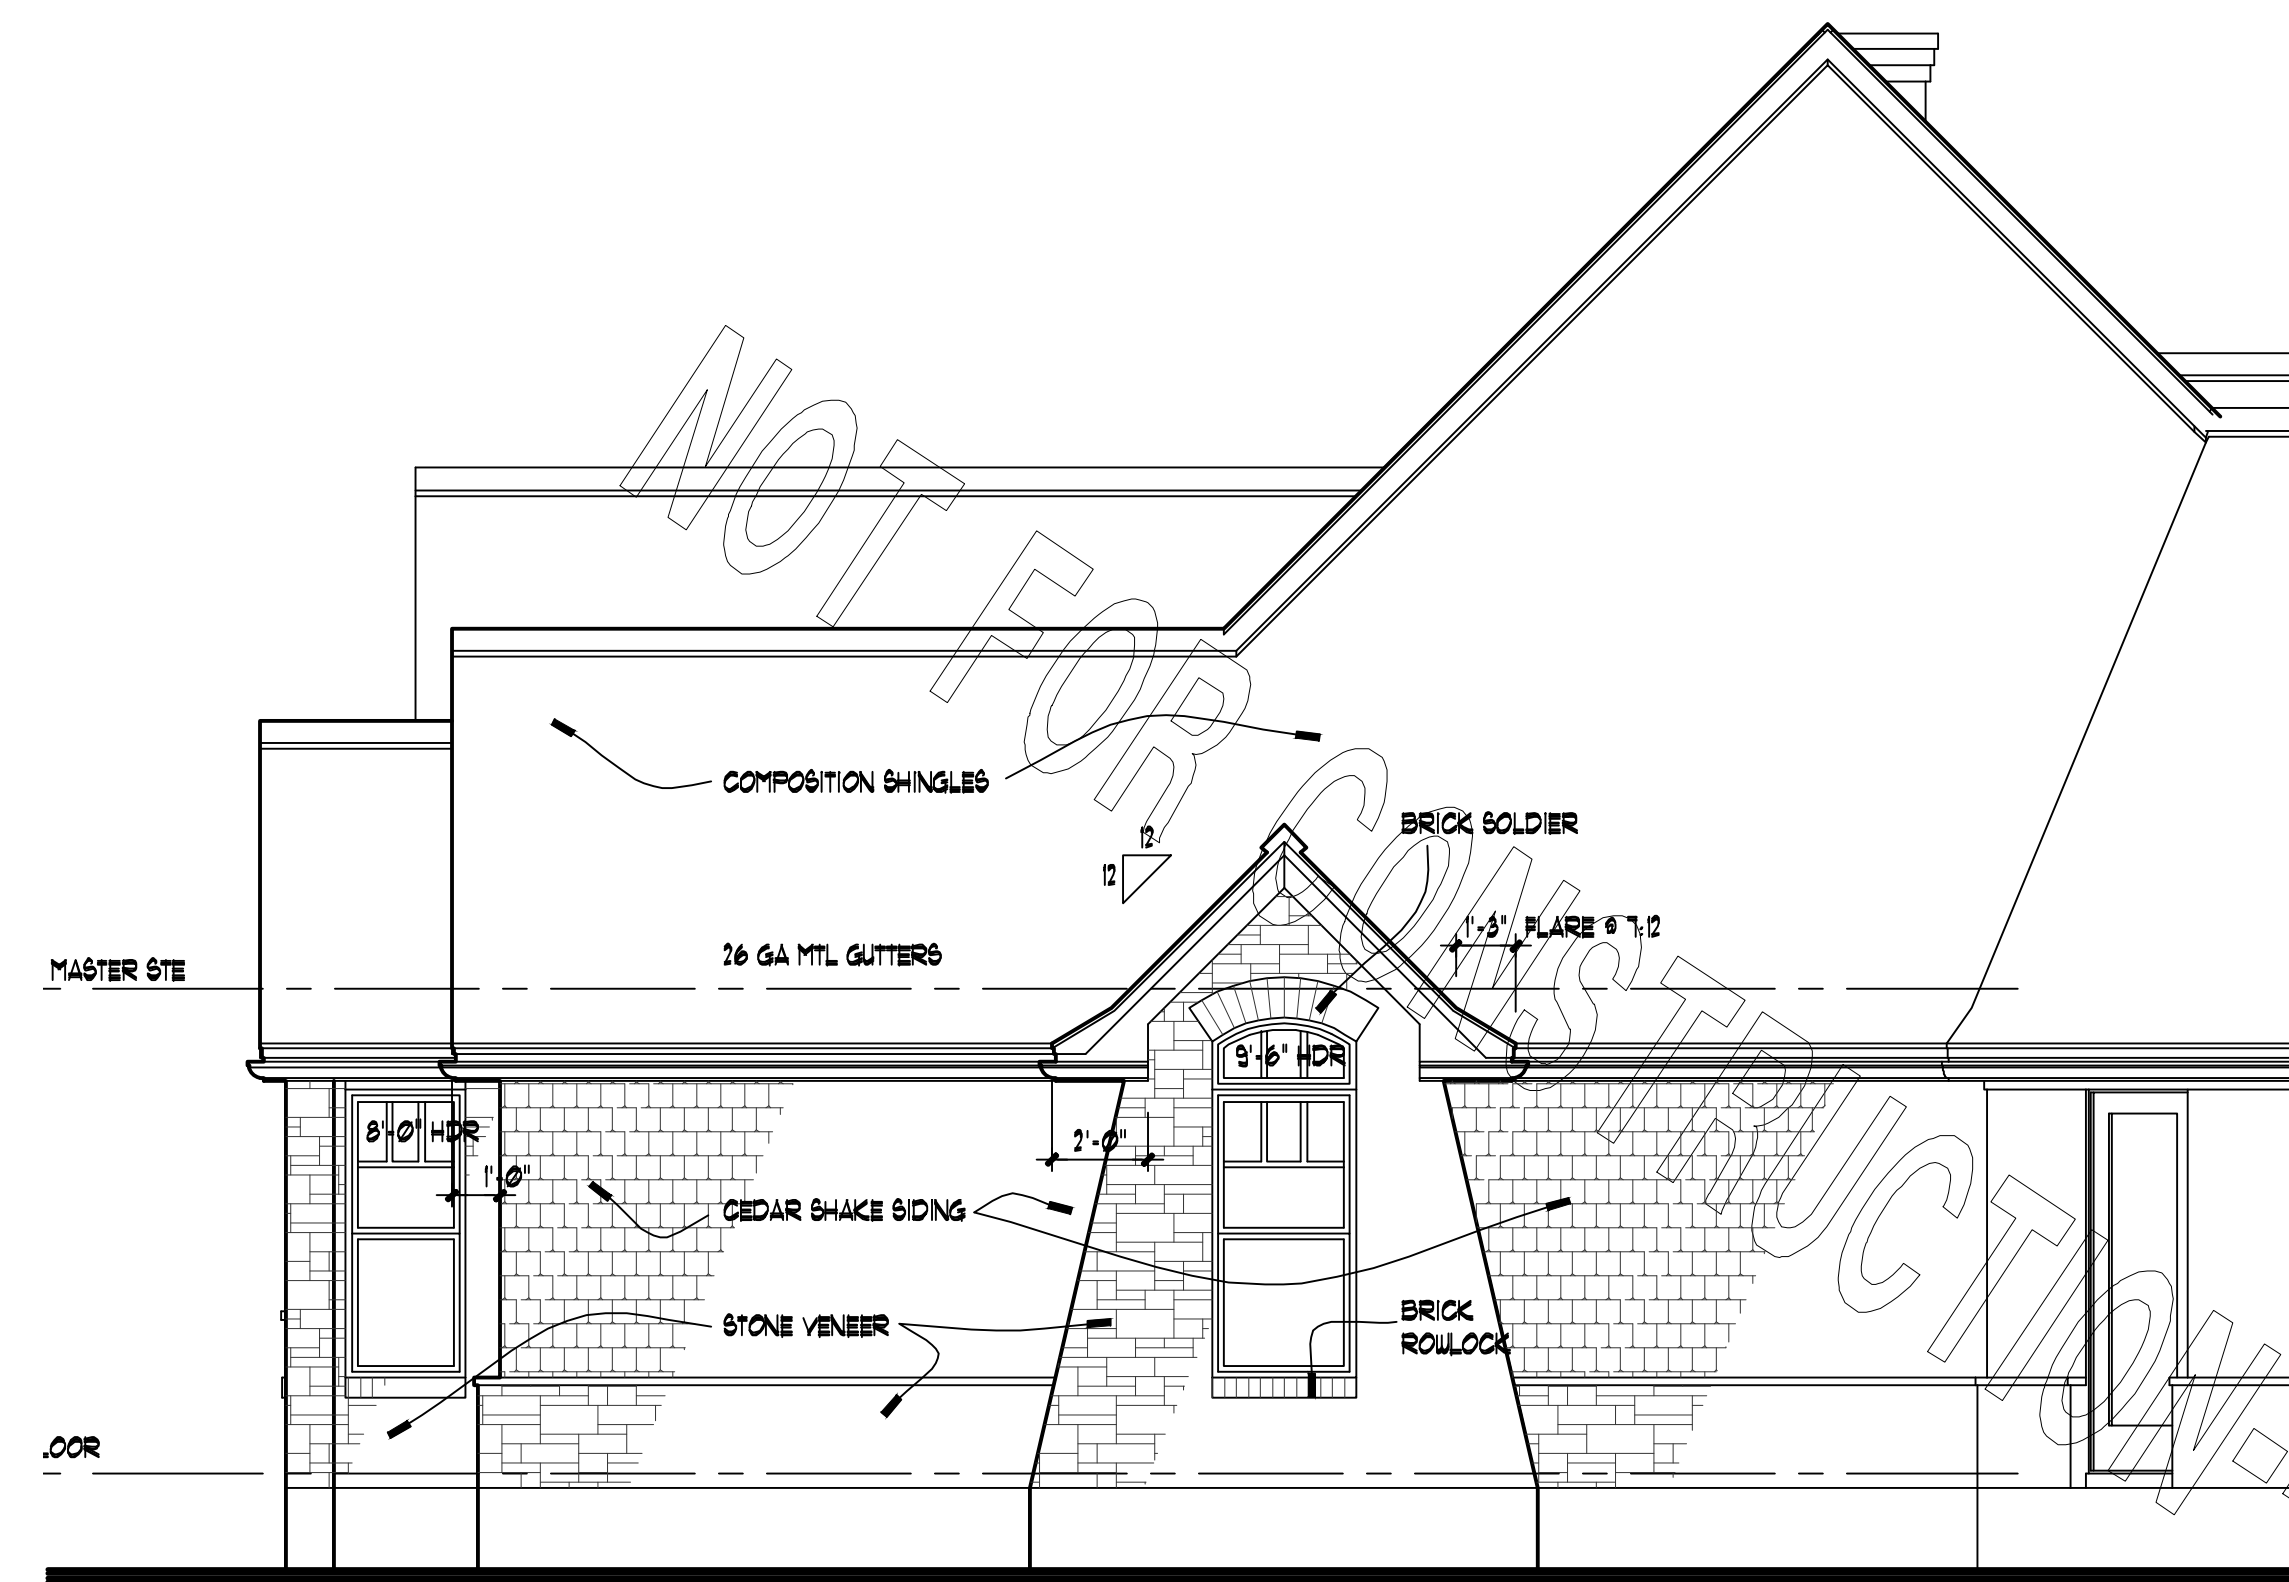


PARTIAL LEFT ELEVATION

SCALE: 1/4" = 1'-0"

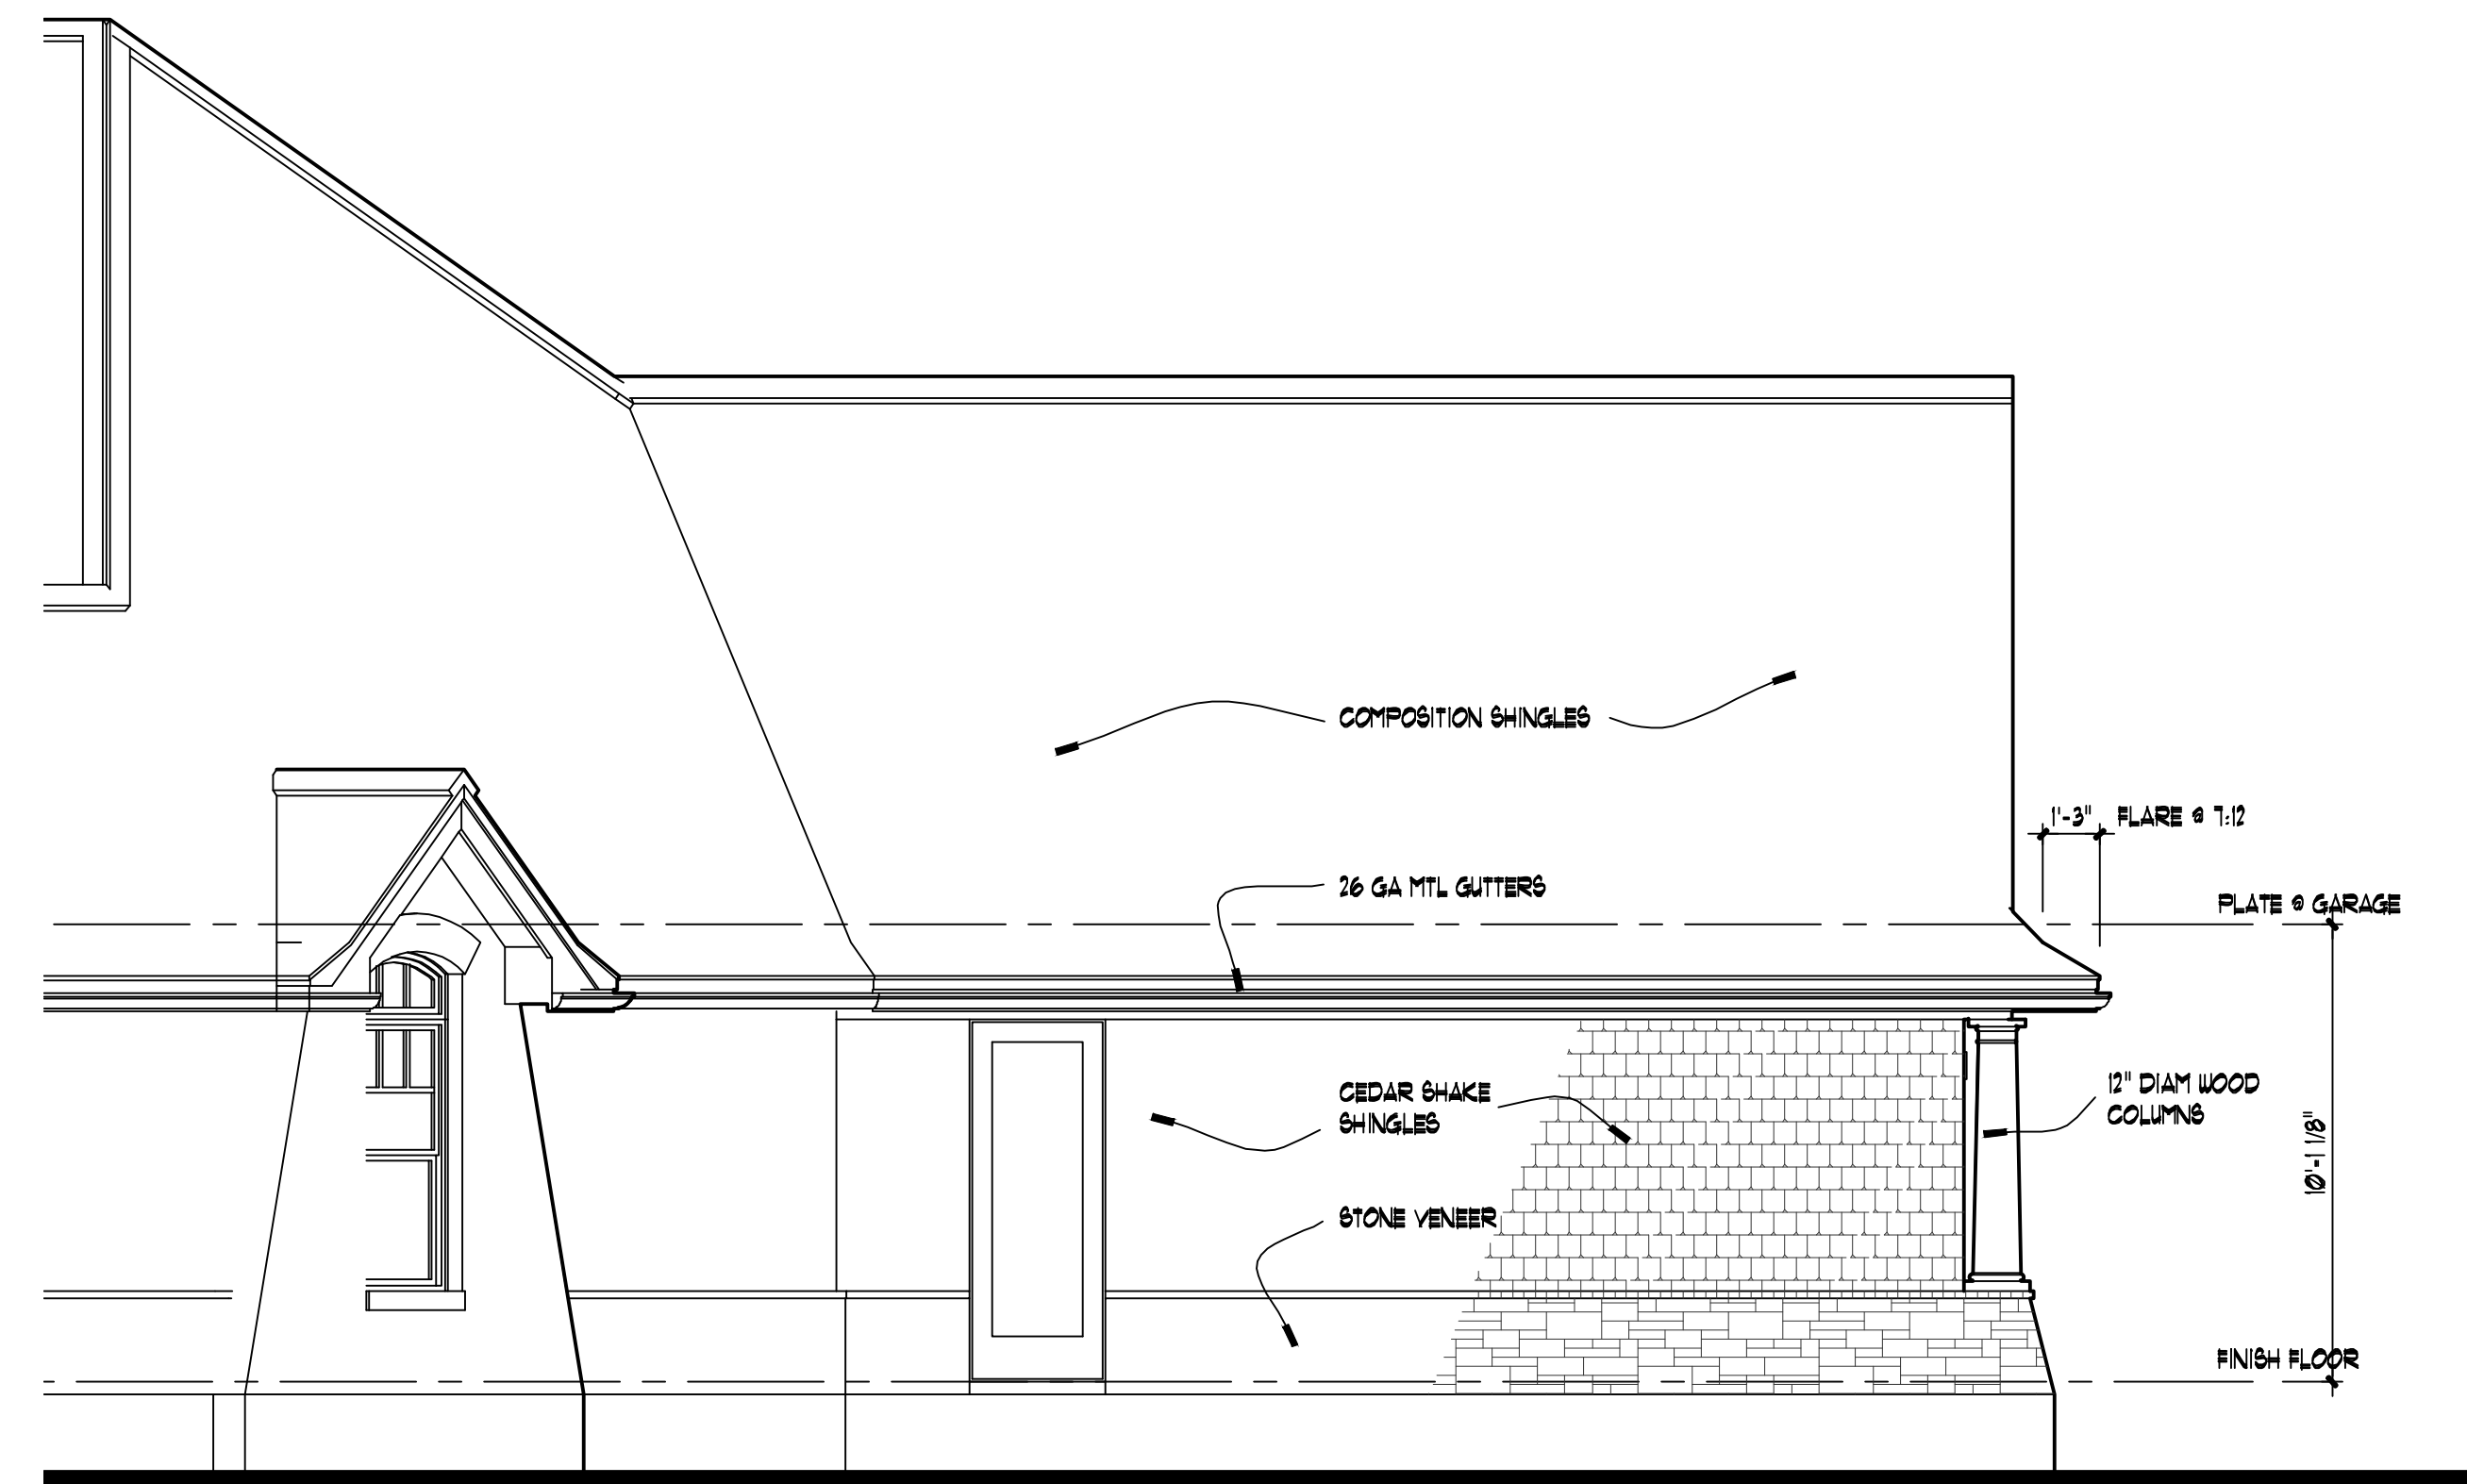


PARTIAL REAR ELEVATION

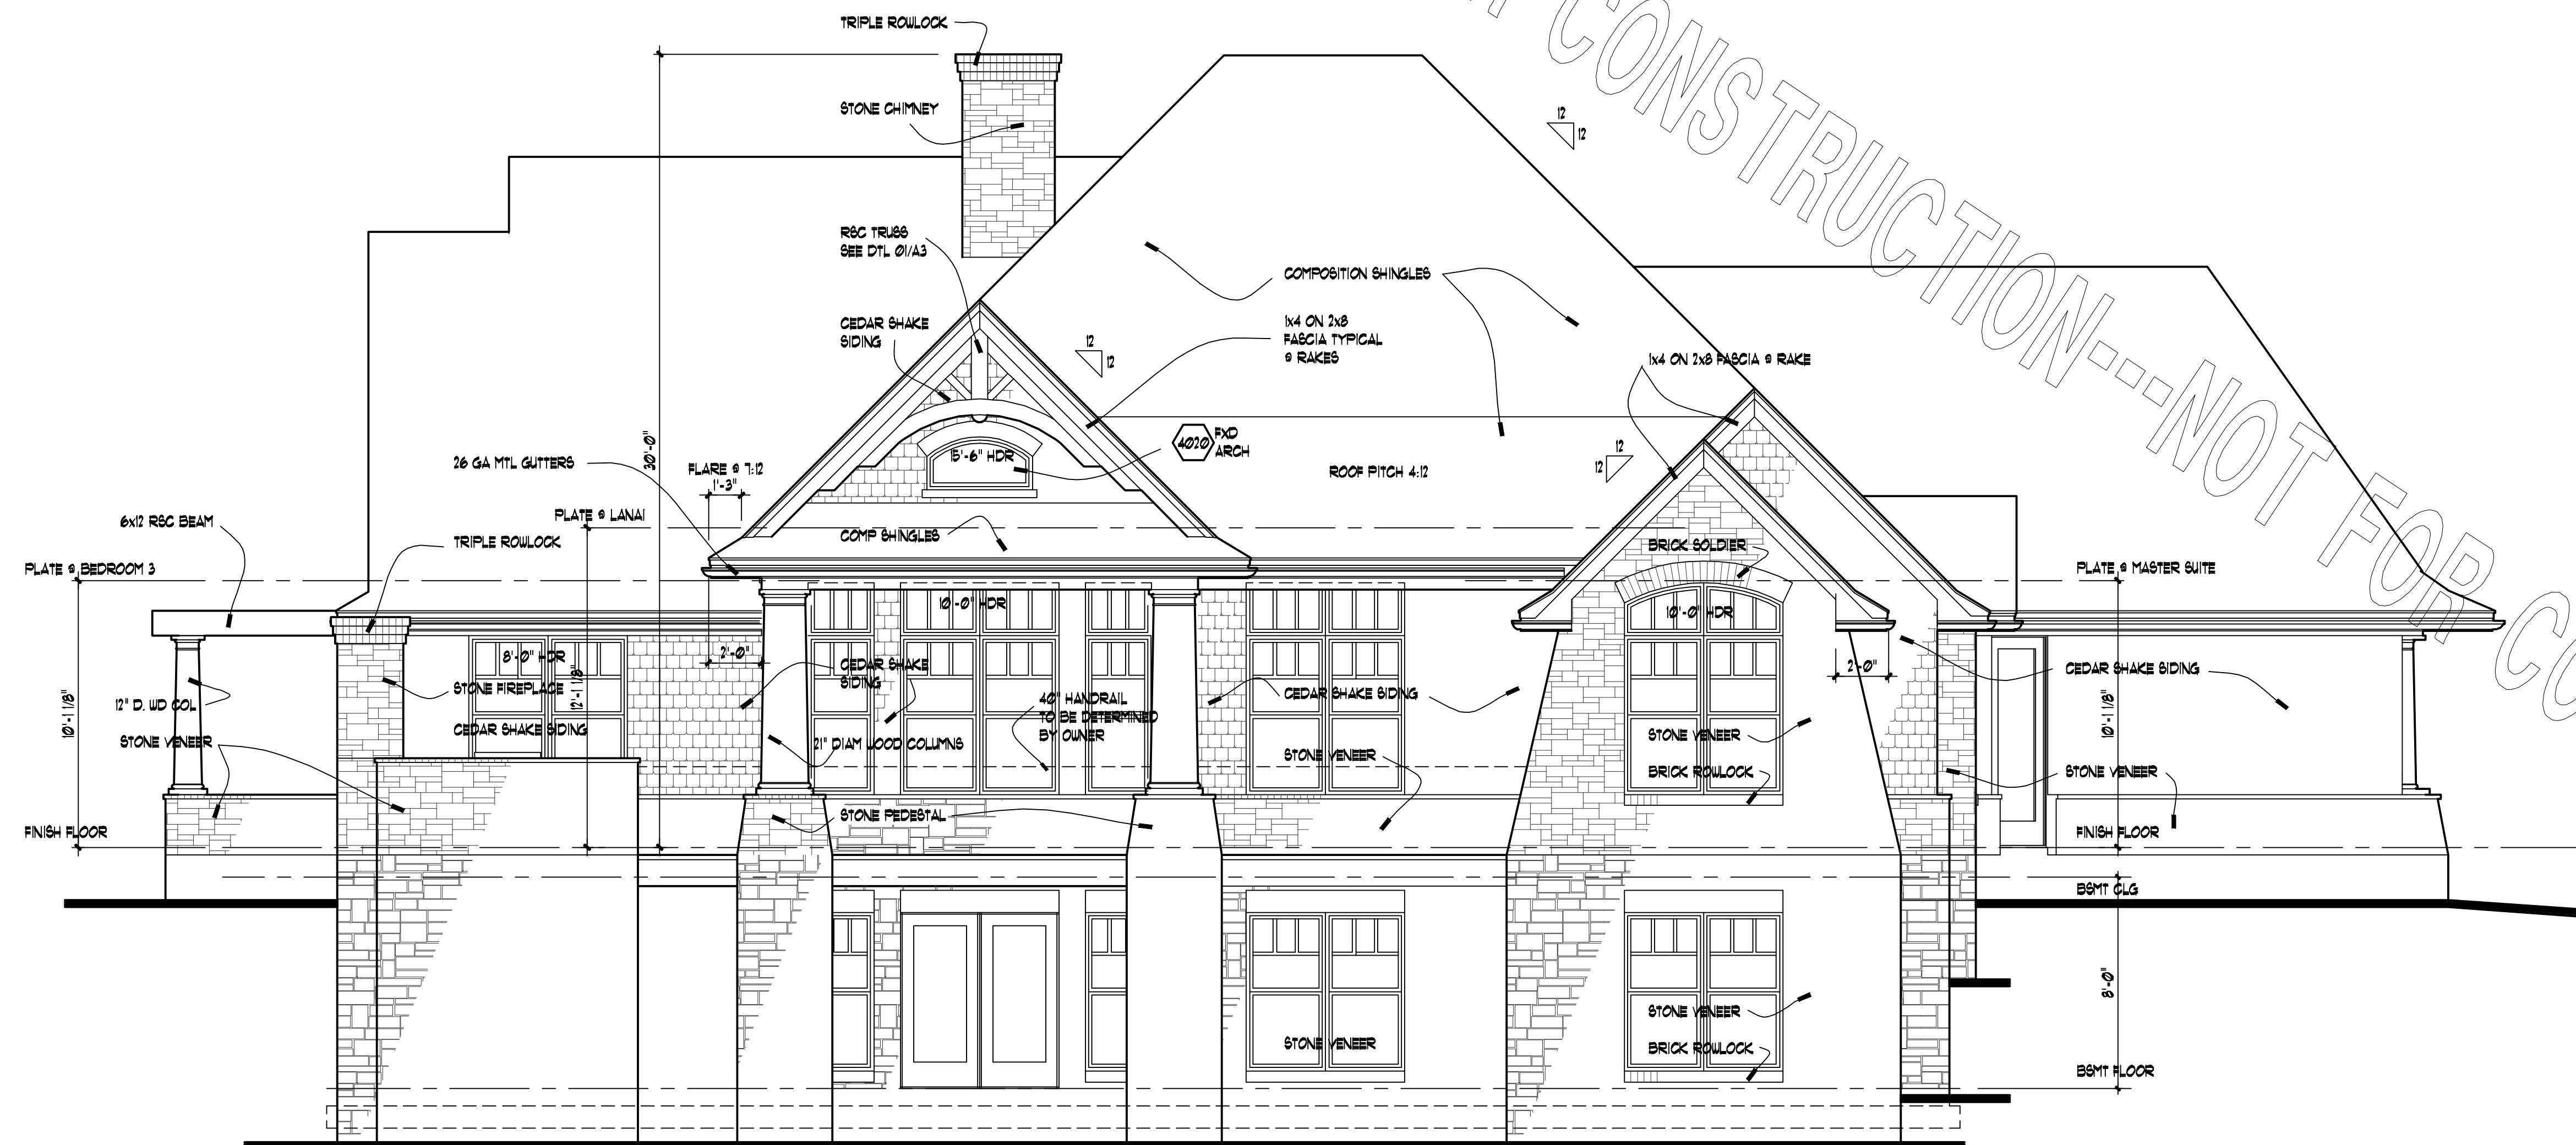


REAR ELEVATION

SCALE: 1/4" = 1'-0"

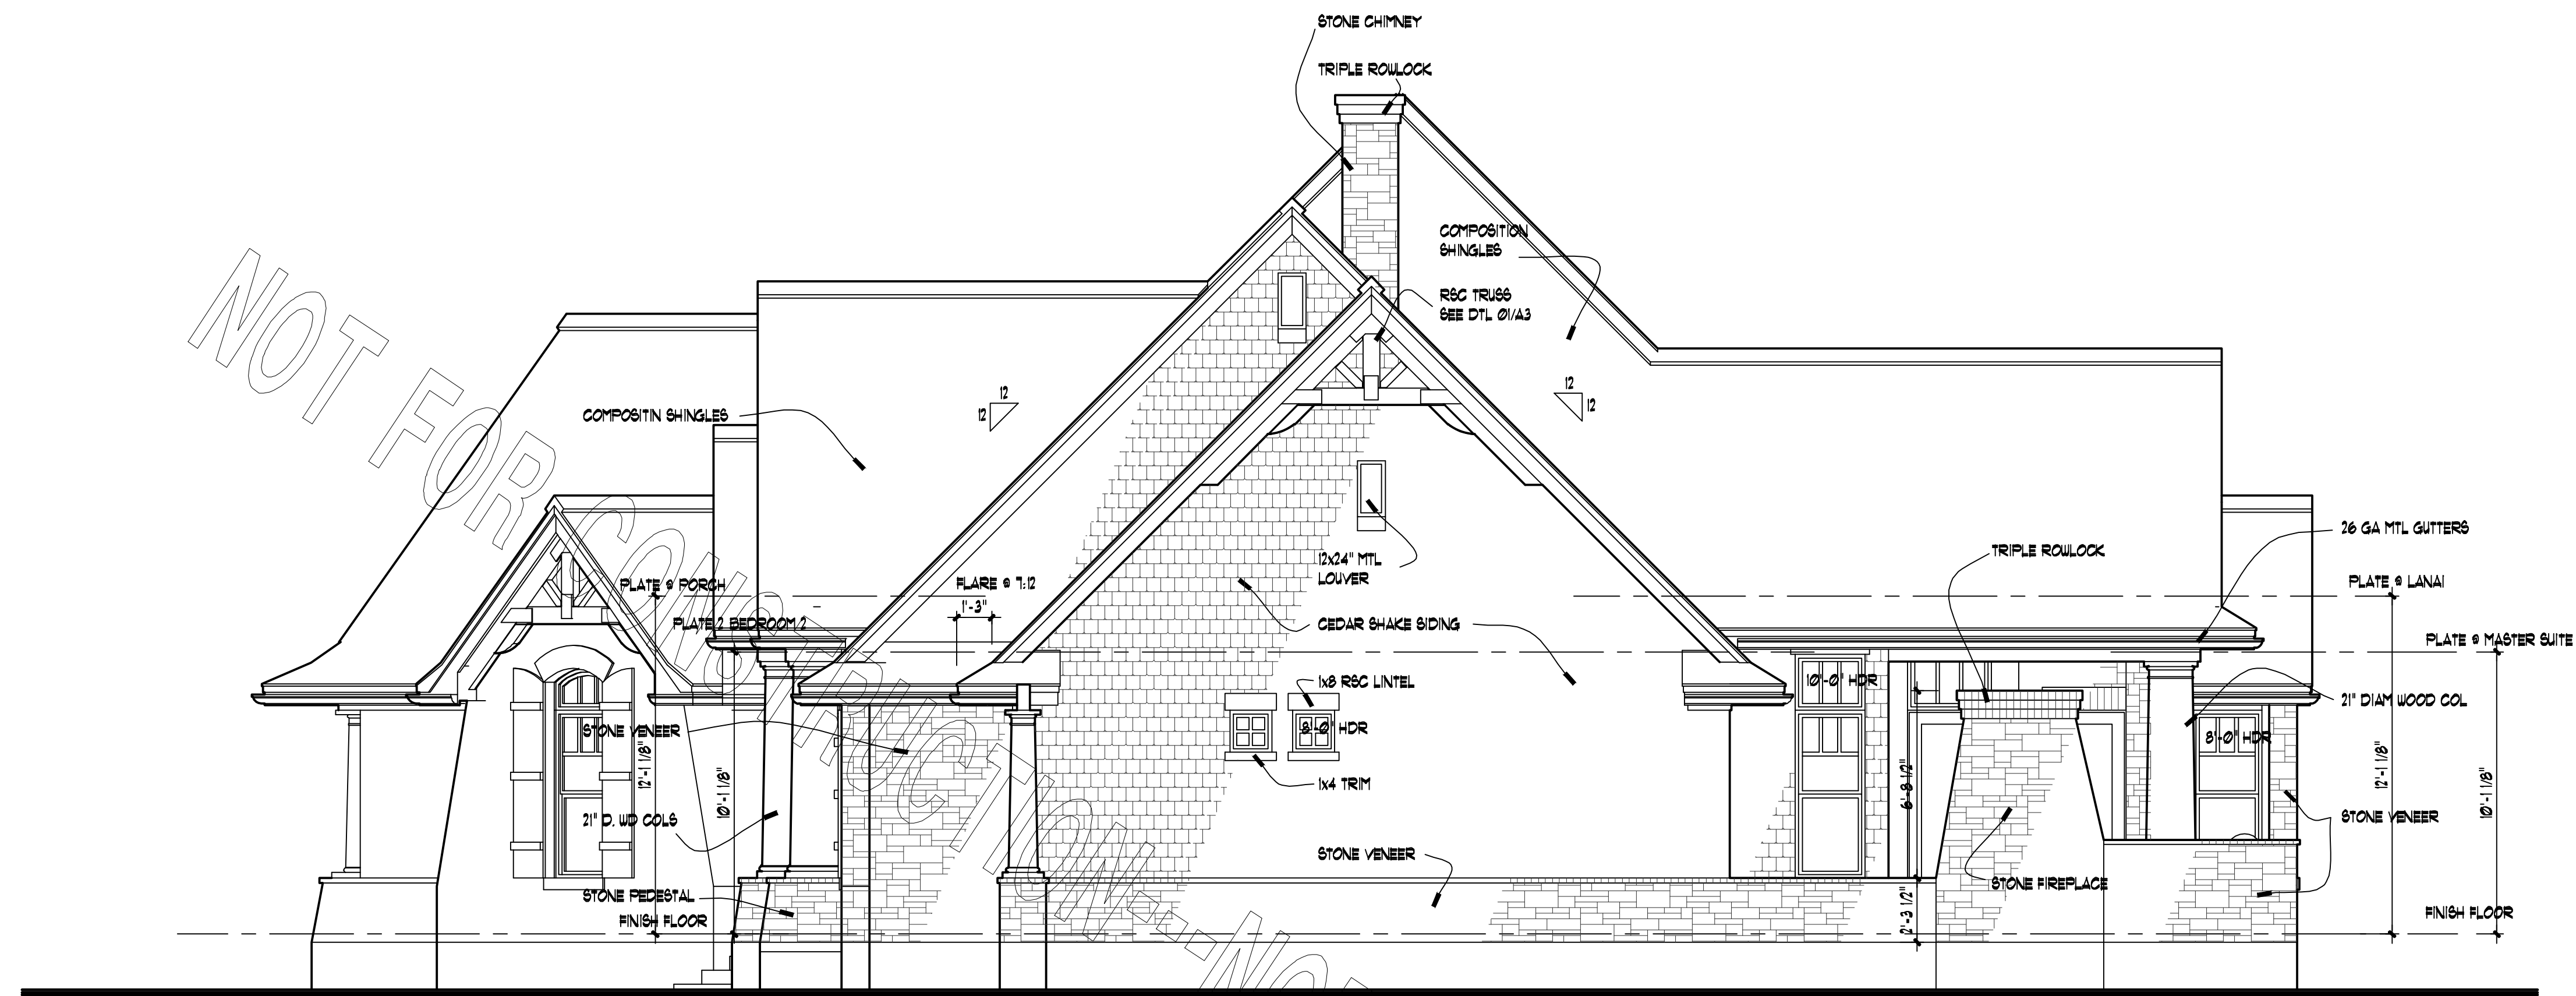


RIGHT ELEVATION

SCALE: 1/4" = 1'-0"

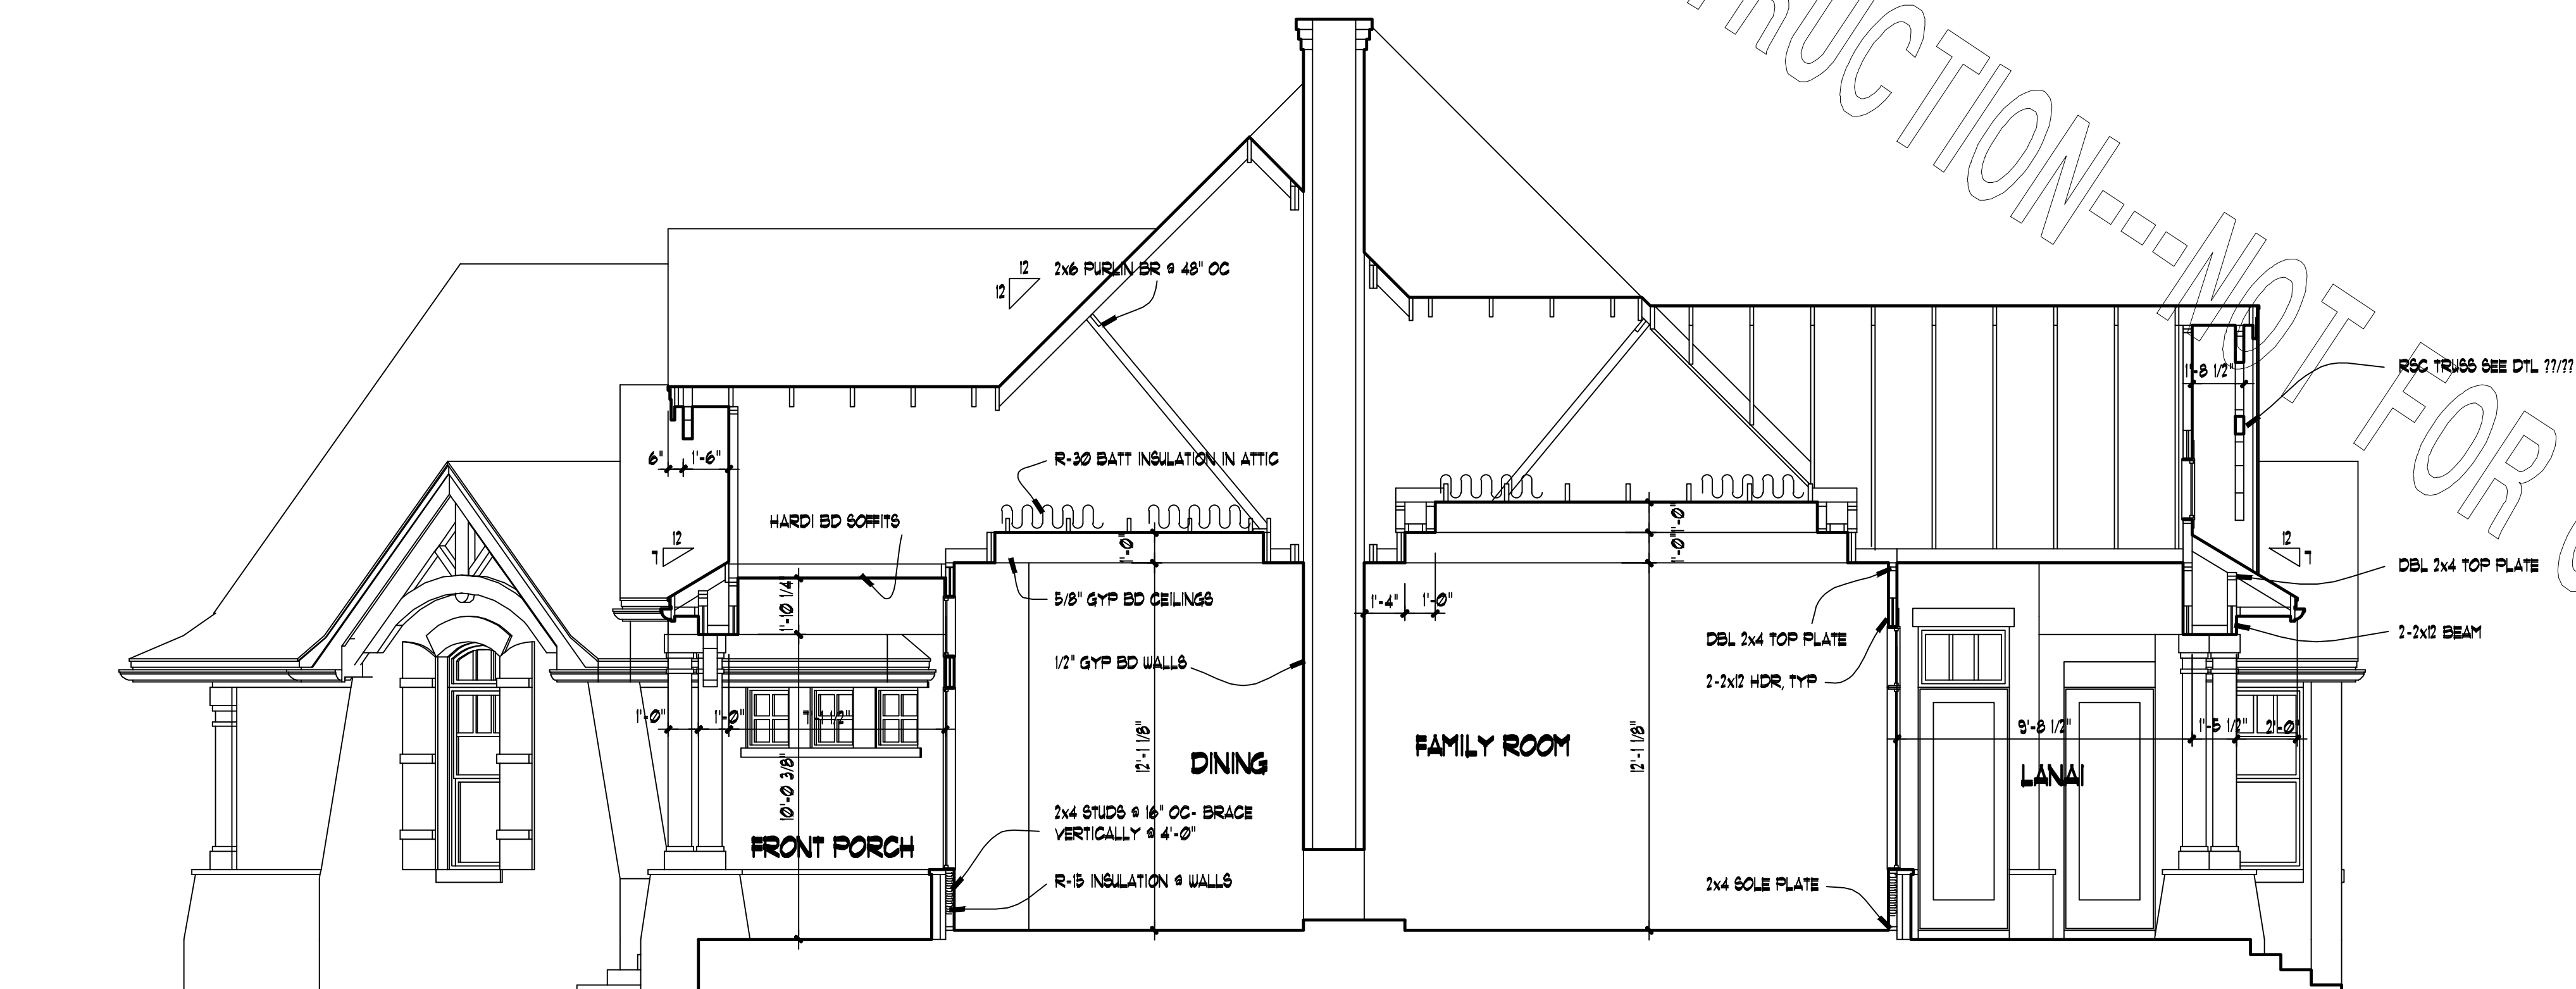


BUILDING SECTION A-A

SCALE: 1/4" = 1'-0"

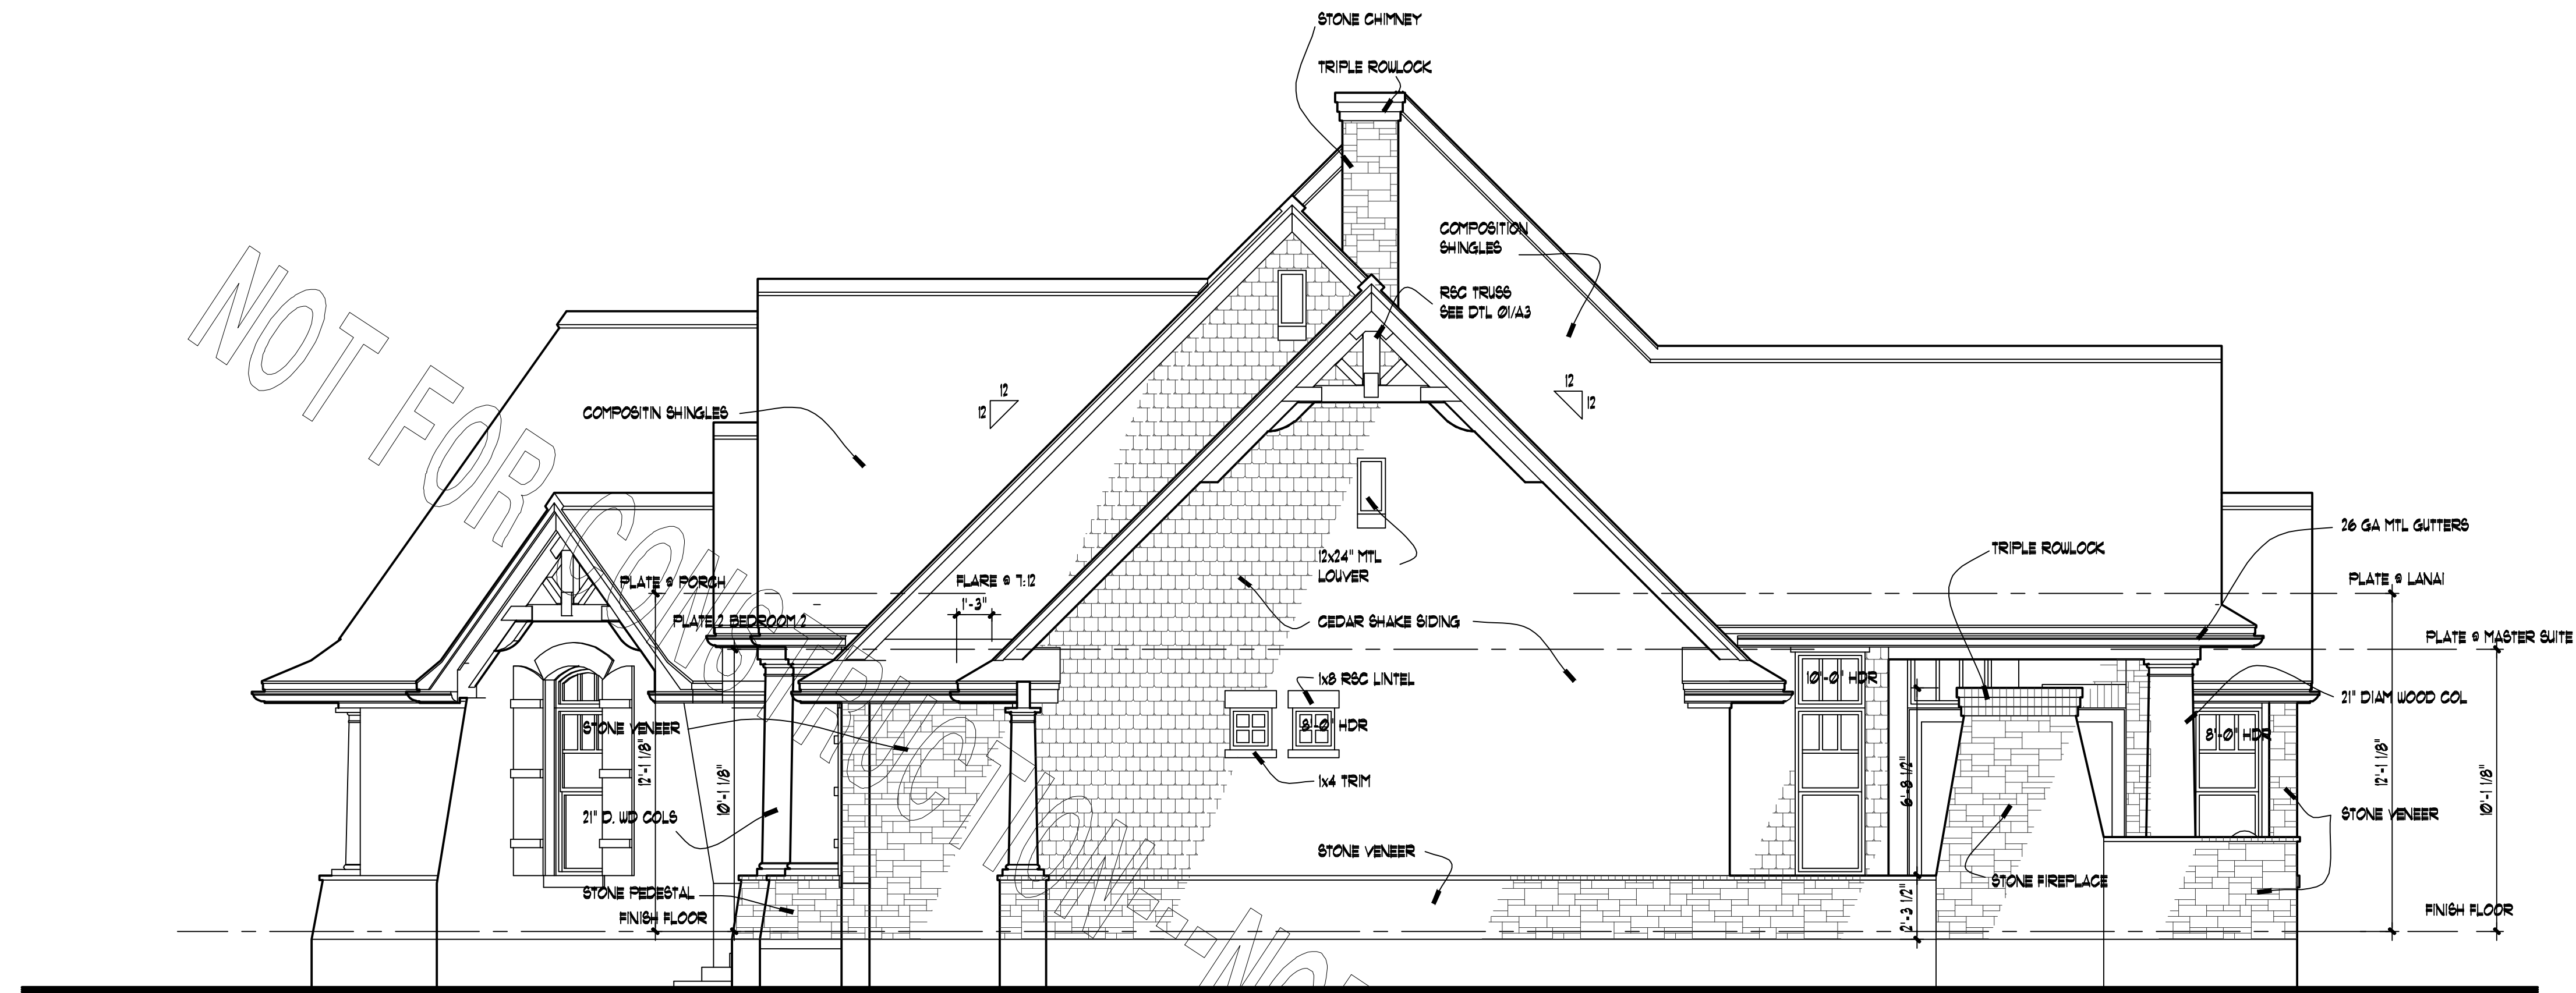


RIGHT ELEVATION

SCALE: 1/4" = 1'-0"

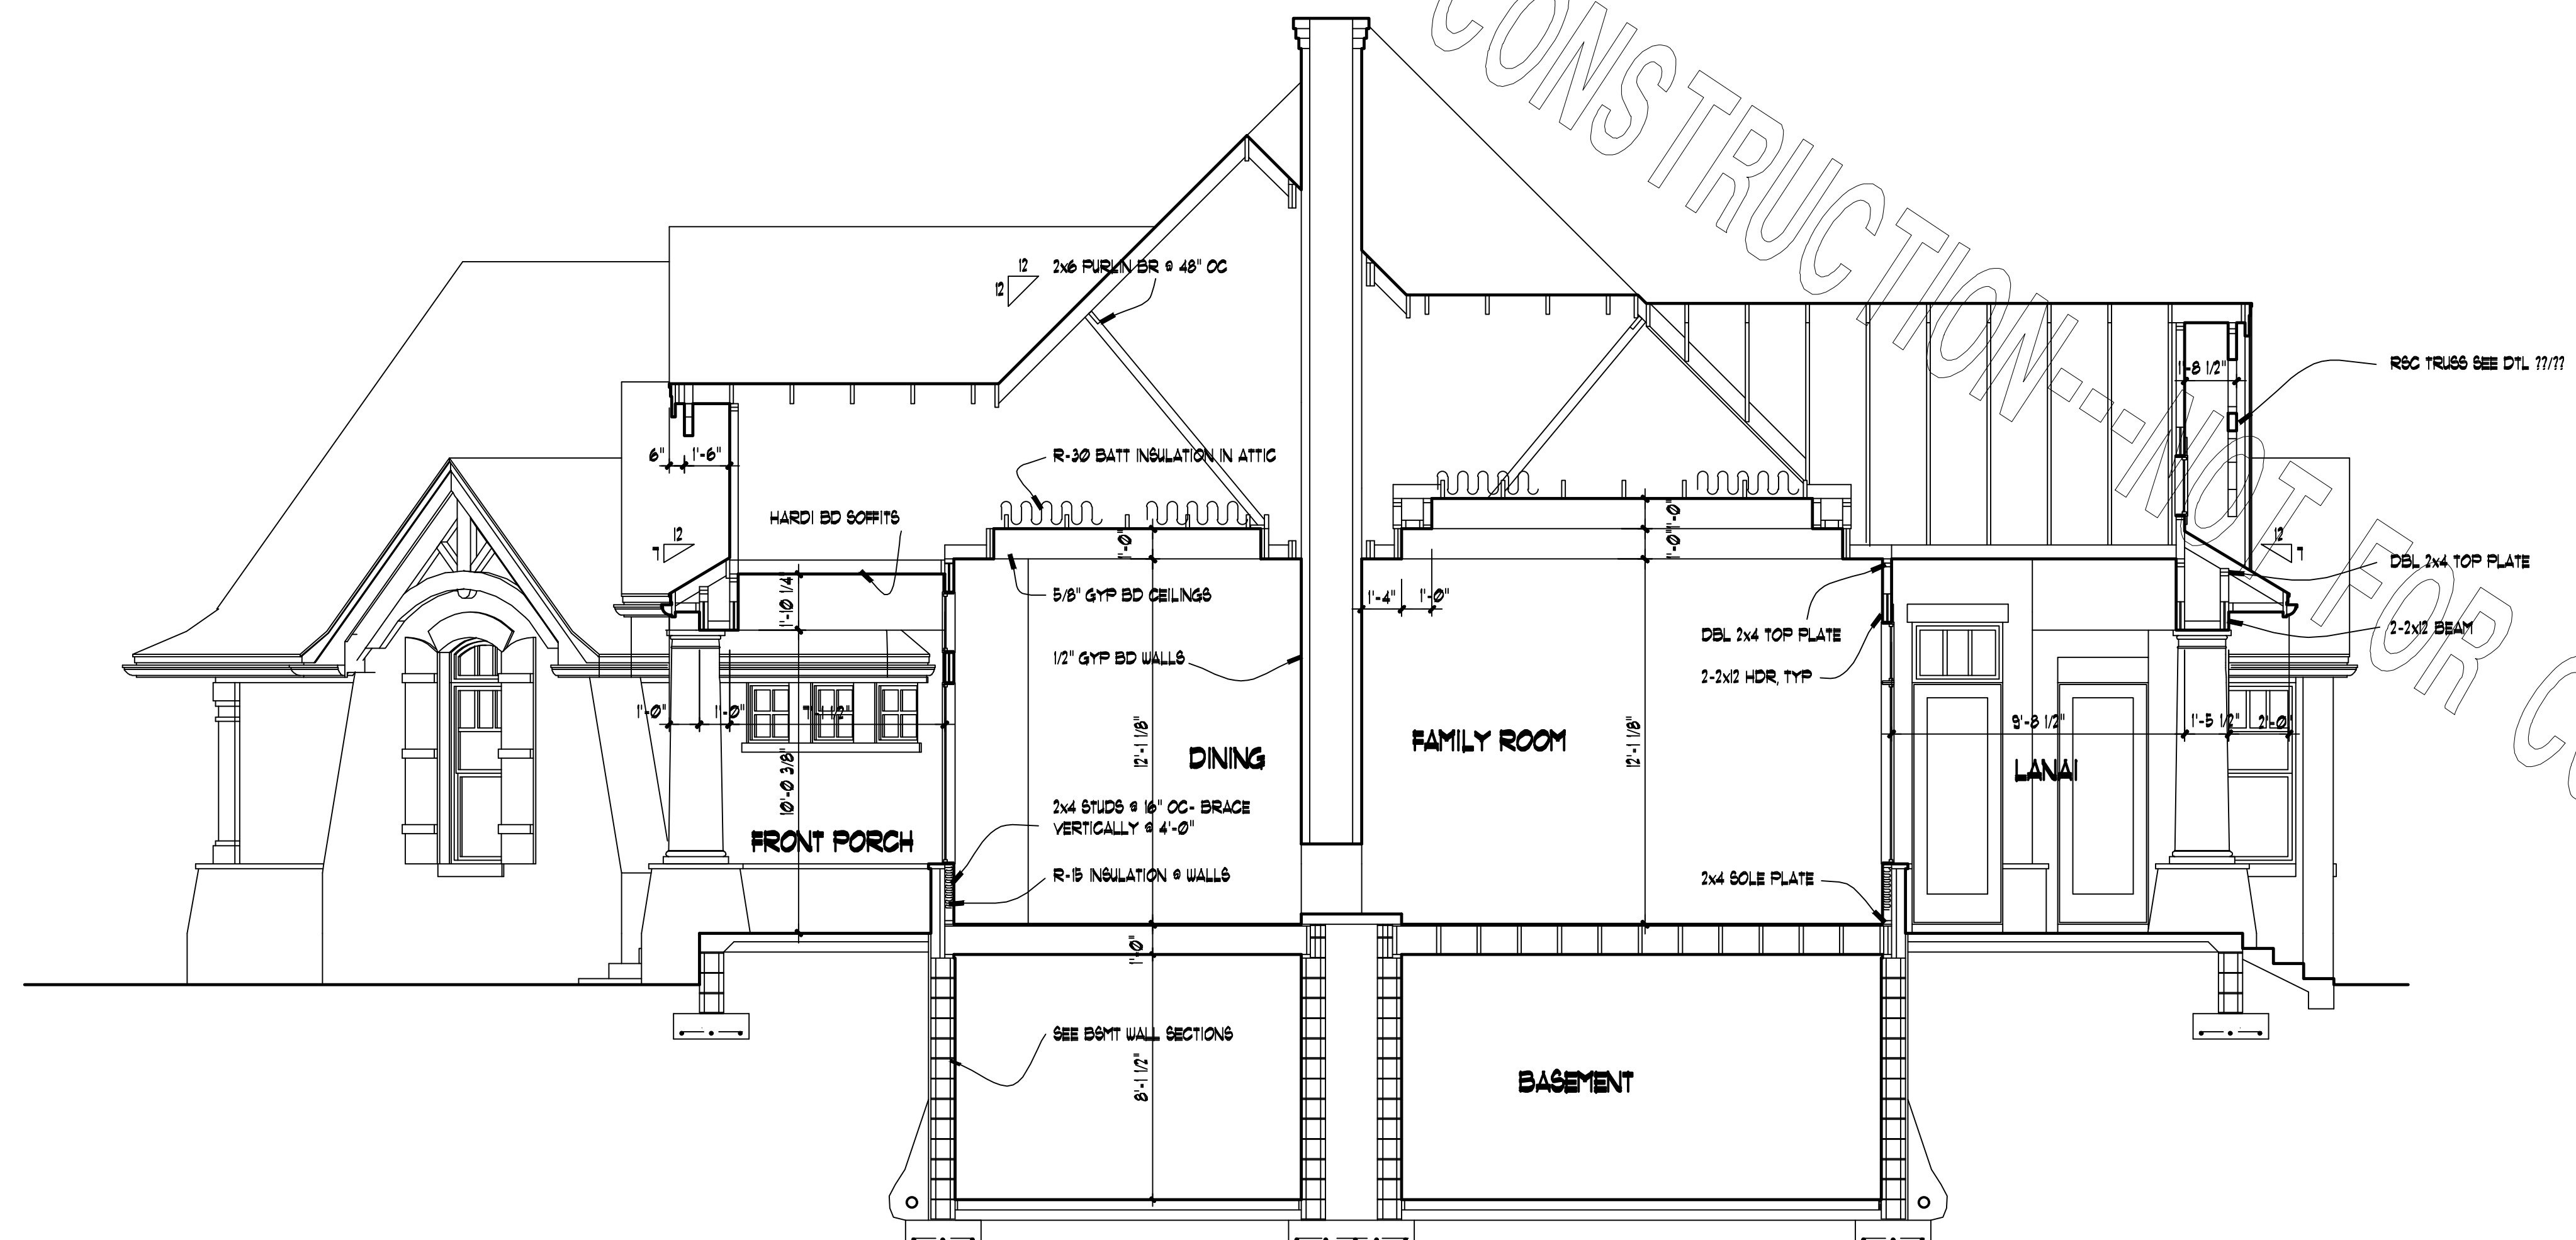


BUILDING SECTION A-A


SCALE: 1/4" = 1'-0"

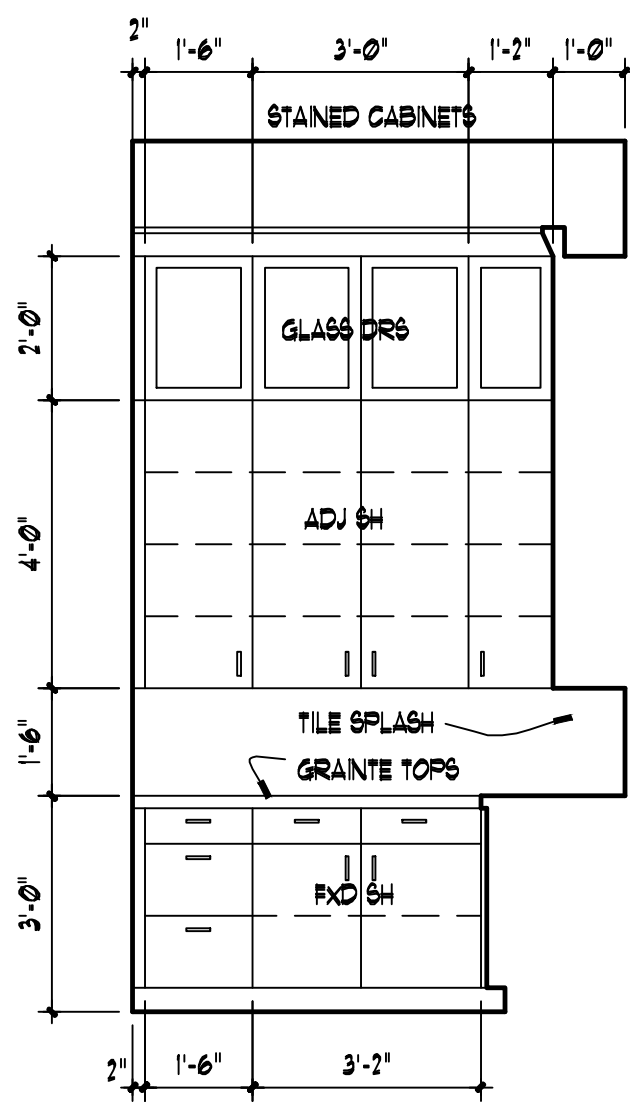


01
A6
KITCHEN
3/8" = 1'-0"

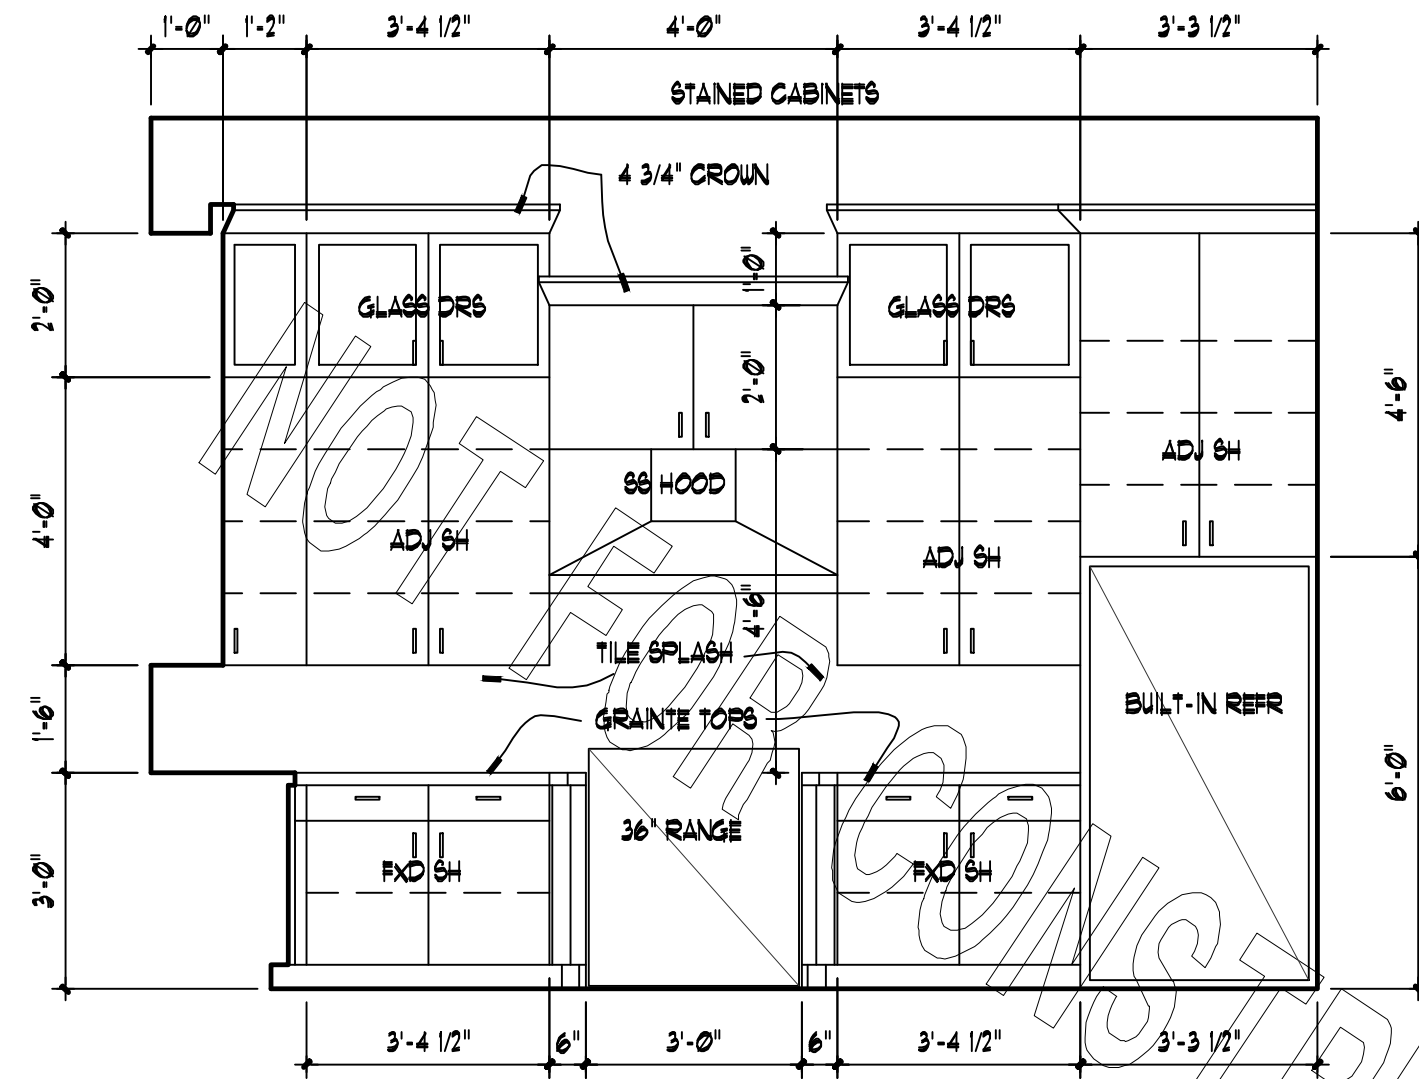


02
A6
KITCHEN
3/8" = 1'-0"

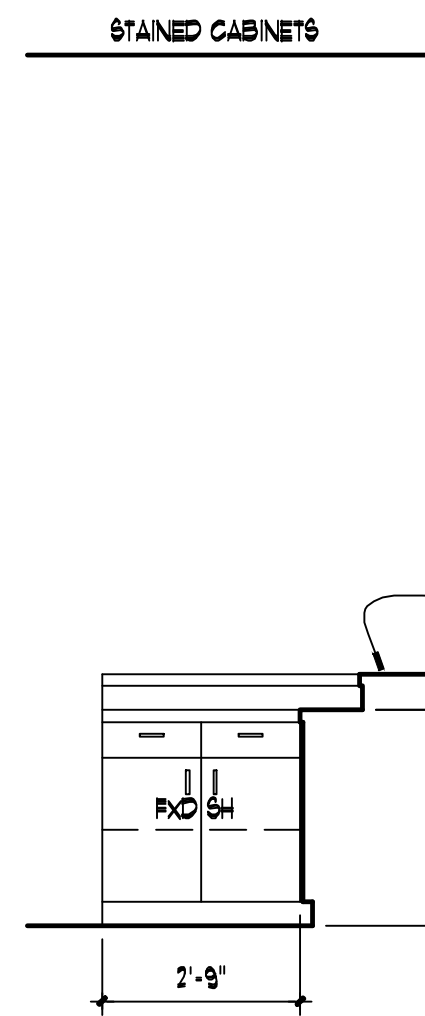


03
A6
KITCHEN
3/8" = 1'-0"

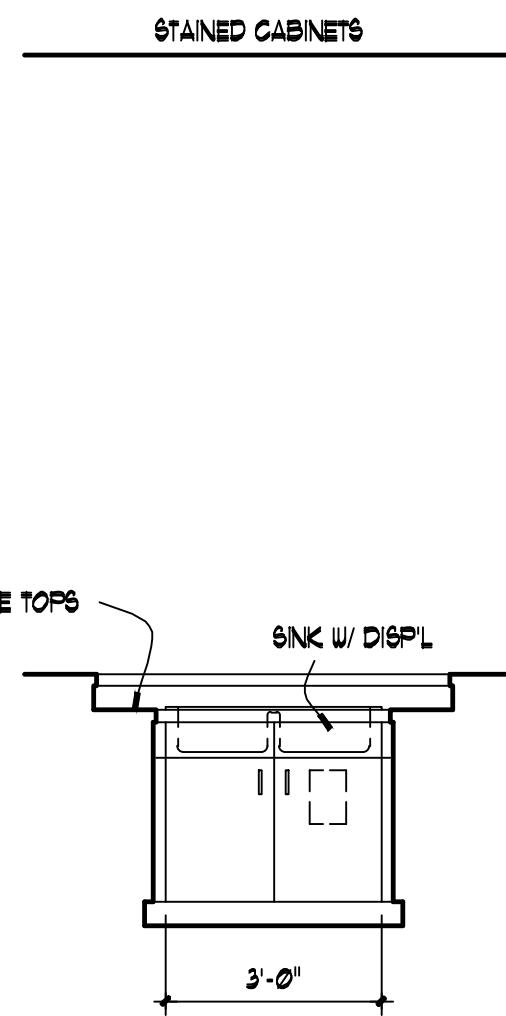


04
A6
KITCHEN
3/8" = 1'-0"

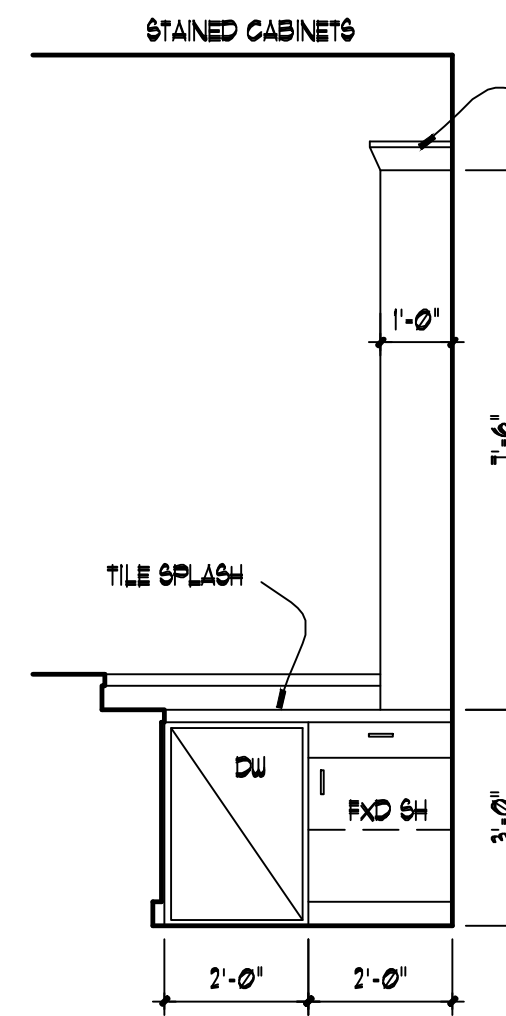


05
A6
KITCHEN
3/8" = 1'-0"

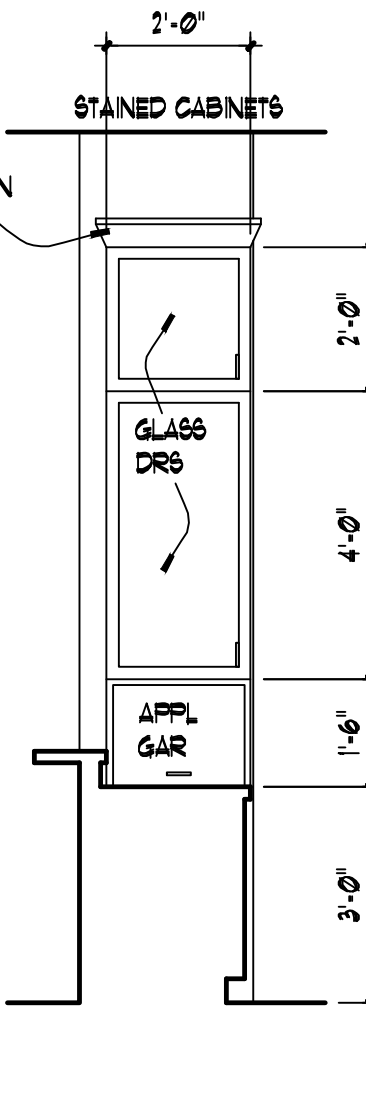


06
A6
KITCHEN
3/8" = 1'-0"

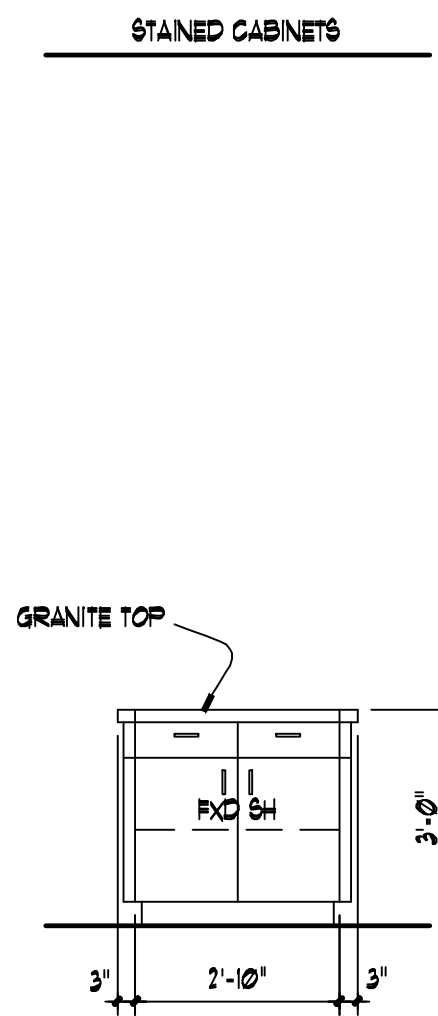


07
A6
KITCHEN
3/8" = 1'-0"

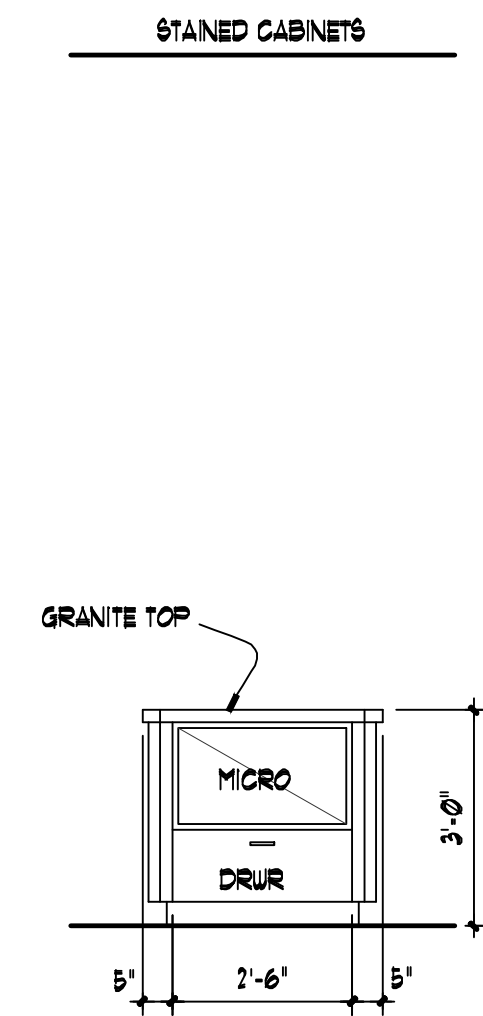


08
A6
KITCHEN
3/8" = 1'-0"

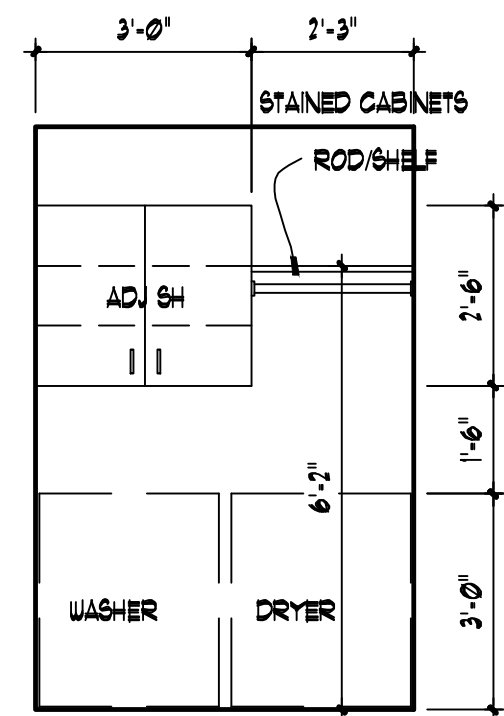


09
A6
UTILITY
3/8" = 1'-0"

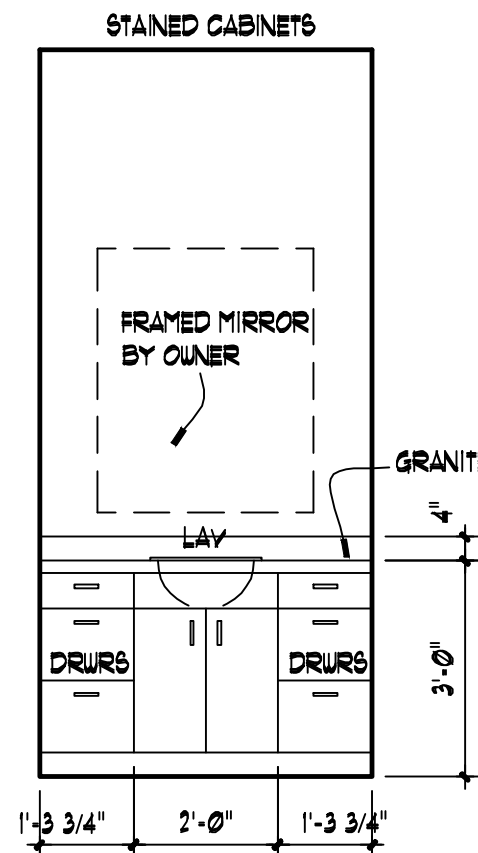


10
A6
MASTER BATH
3/8" = 1'-0"

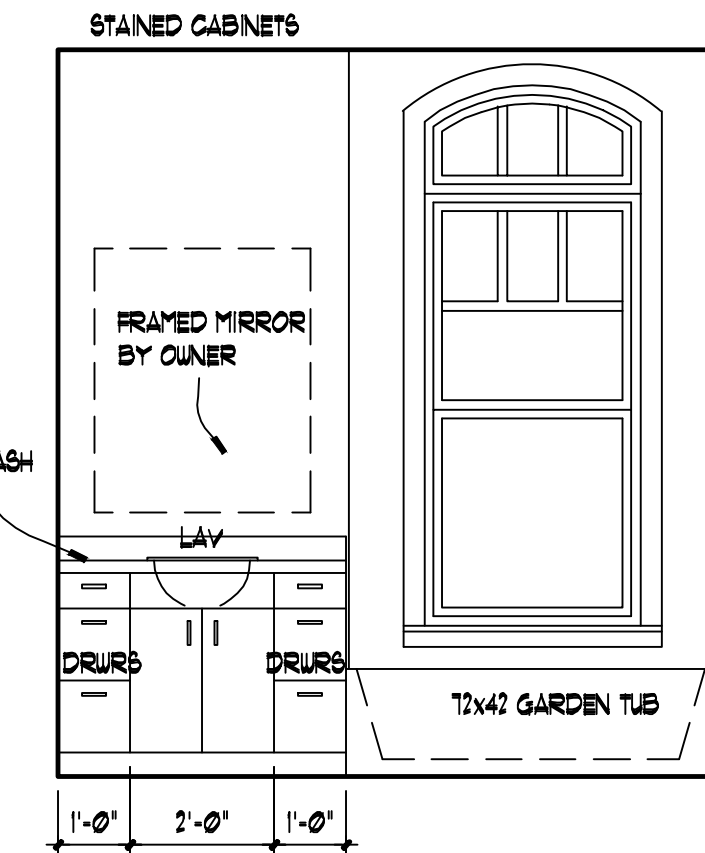


11
A6
MASTER BATH
3/8" = 1'-0"

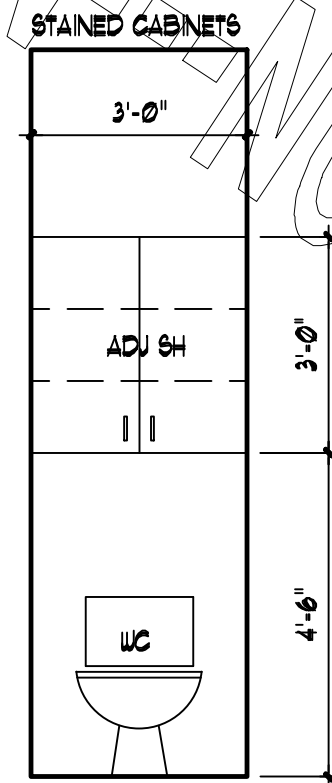


12
A6
MASTER BATH
3/8" = 1'-0"

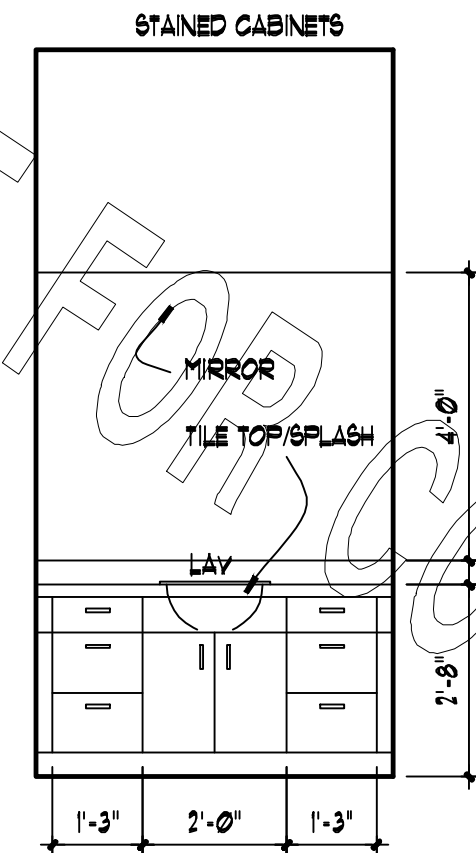

13
A6
BATH 2
3/8" = 1'-0"

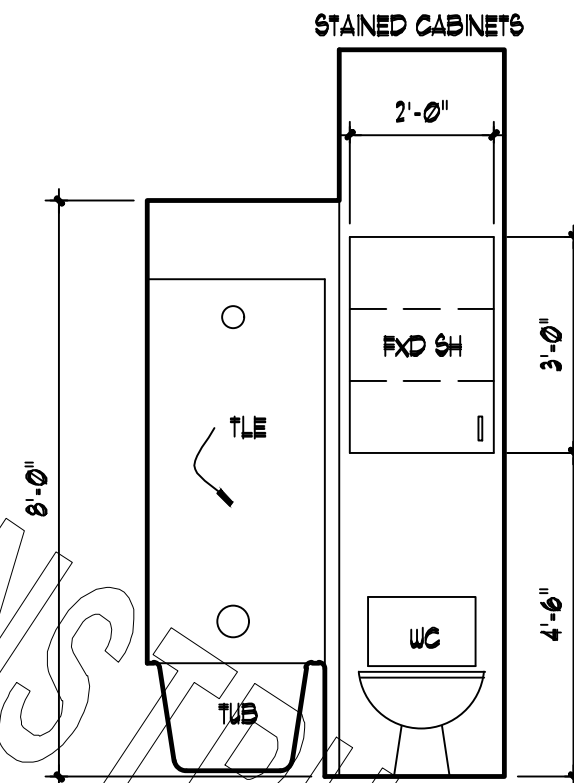

14
A6
BATH 2
3/8" = 1'-0"

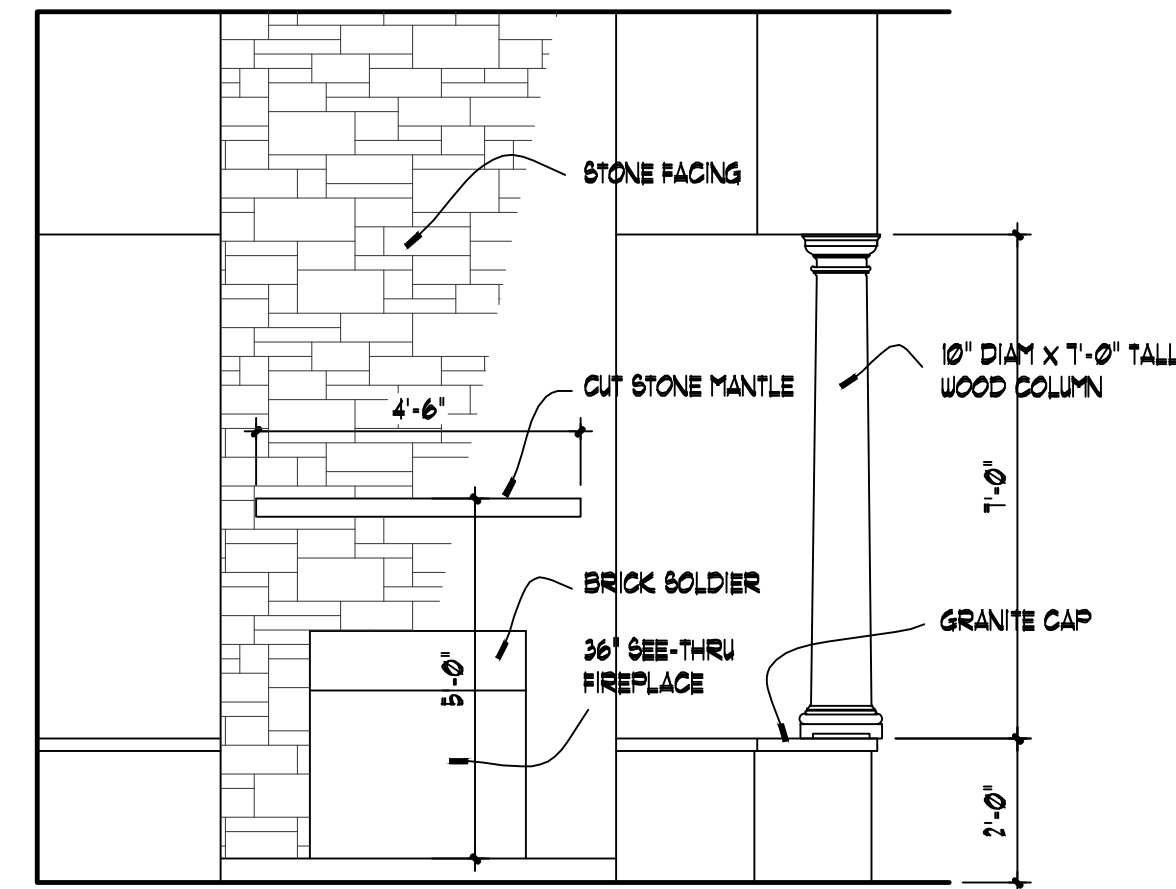

15
A6
FAMILY ROOM
3/8" = 1'-0"

BONUS CEILING FRAMING PLAN

SCALE: 1/4" = 1'-0"


FIRST FLOOR CEILING FRAMING PLAN

SCALE: 1/4" = 1'-0"

HEADER SCHEDULE		
FIRST FLOOR:		
OPNG. SIZE		
2'-3"		2-2x10'S
4'-UP		2-2x12'S
SECOND FLOOR:		
OPNG. SIZE		
2'-3"		2-2x6'S
4'		2-2x8'S
5'		2-2x10'S
6'-UP		2-2x12'S
ALL LUMBER INDICATED SHALL BE		
12 SYPKD SYP, FIR OR SPRUCE		


BONUS ELECTRICAL PLAN

SCALE: 1/4" = 1'-0"

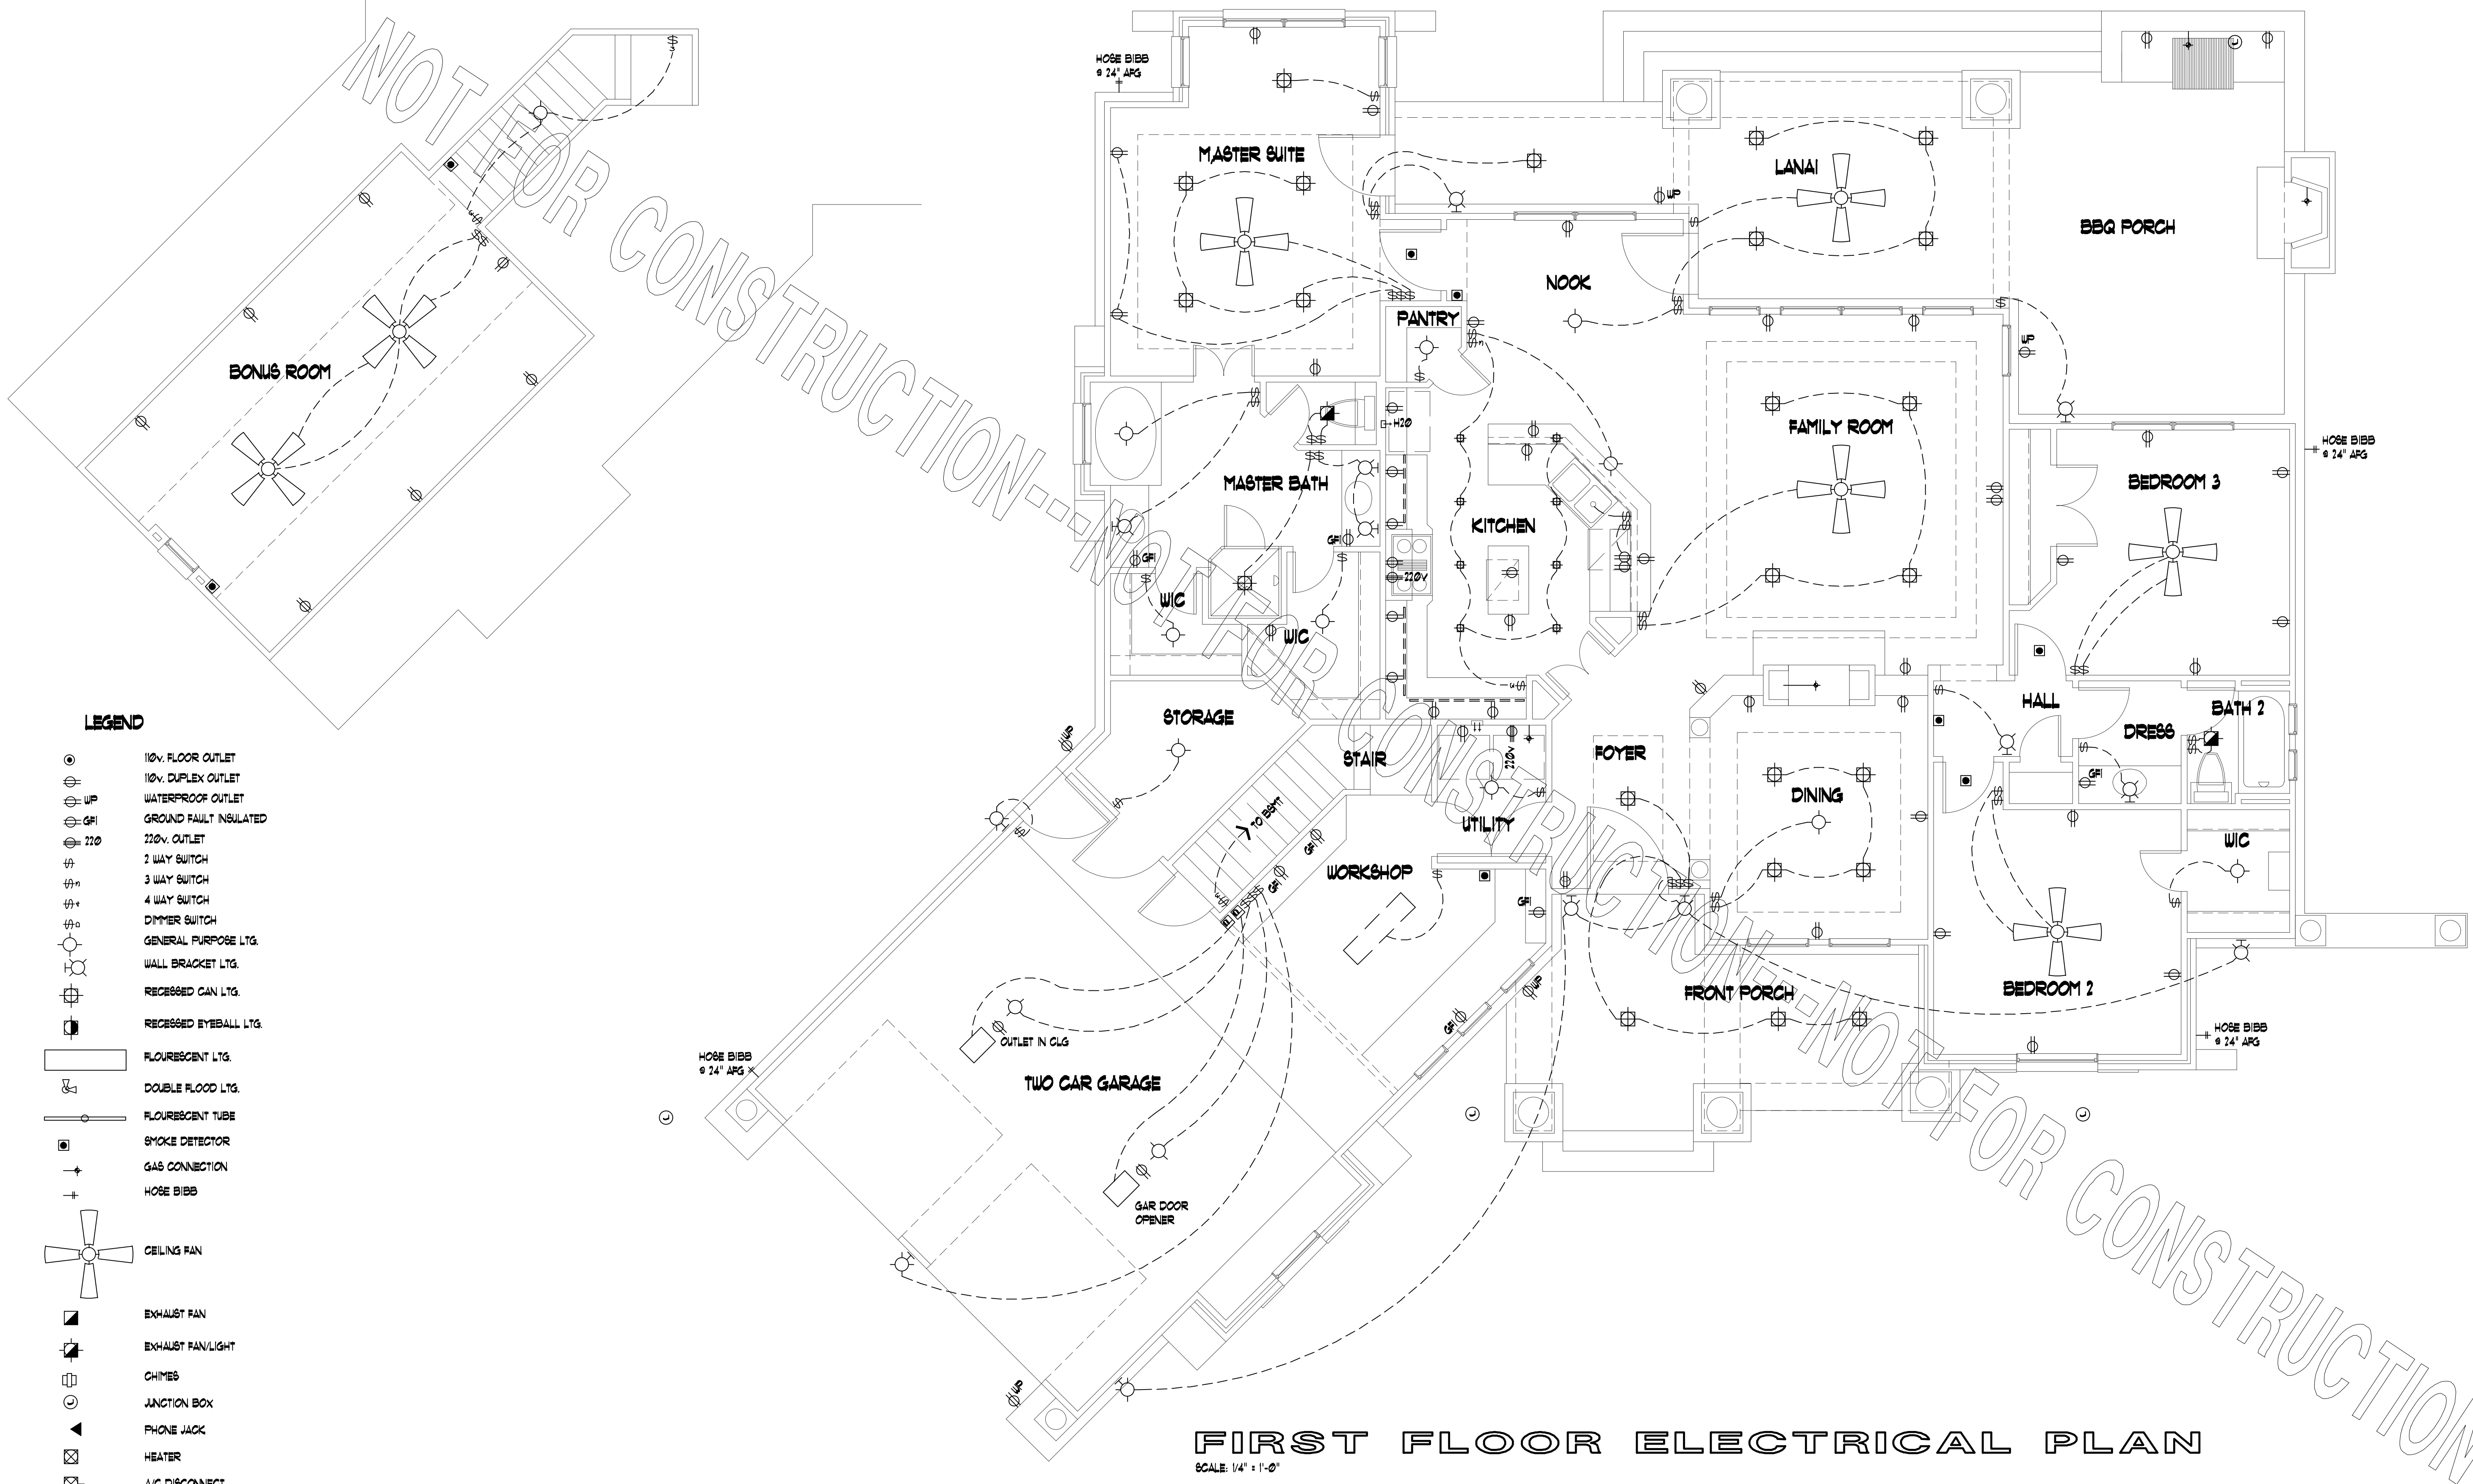


NOTES:


1. ALL FRAMING MEMBERS SHALL BE #2 SYP. FIR OR SPRUCE AND SHALL BE TREATED "M.T.L." & ALL CRAWL SPACE AREAS.
2. PROVIDE SOLID BLKG. @ MID-SPAN OR @ 8'-6" O.C. MAX. SPACING.
3. CONTRACTOR SHALL VERIFY ALL BEAM SIZES WITH ENGINEER.
4. PROVIDE REIN. @ CMU WALLS OF #5 @ 48" O.C. IN FULLY GROUTED CELLS.
5. PROVIDE 3-#5 @ CONT. @ BOT. OF ALL CONT. CONC. FOOTINGS.
6. PROVIDE 3-#5 @ EA. WAY @ BOT. OF SPOT CONC. FTGS.


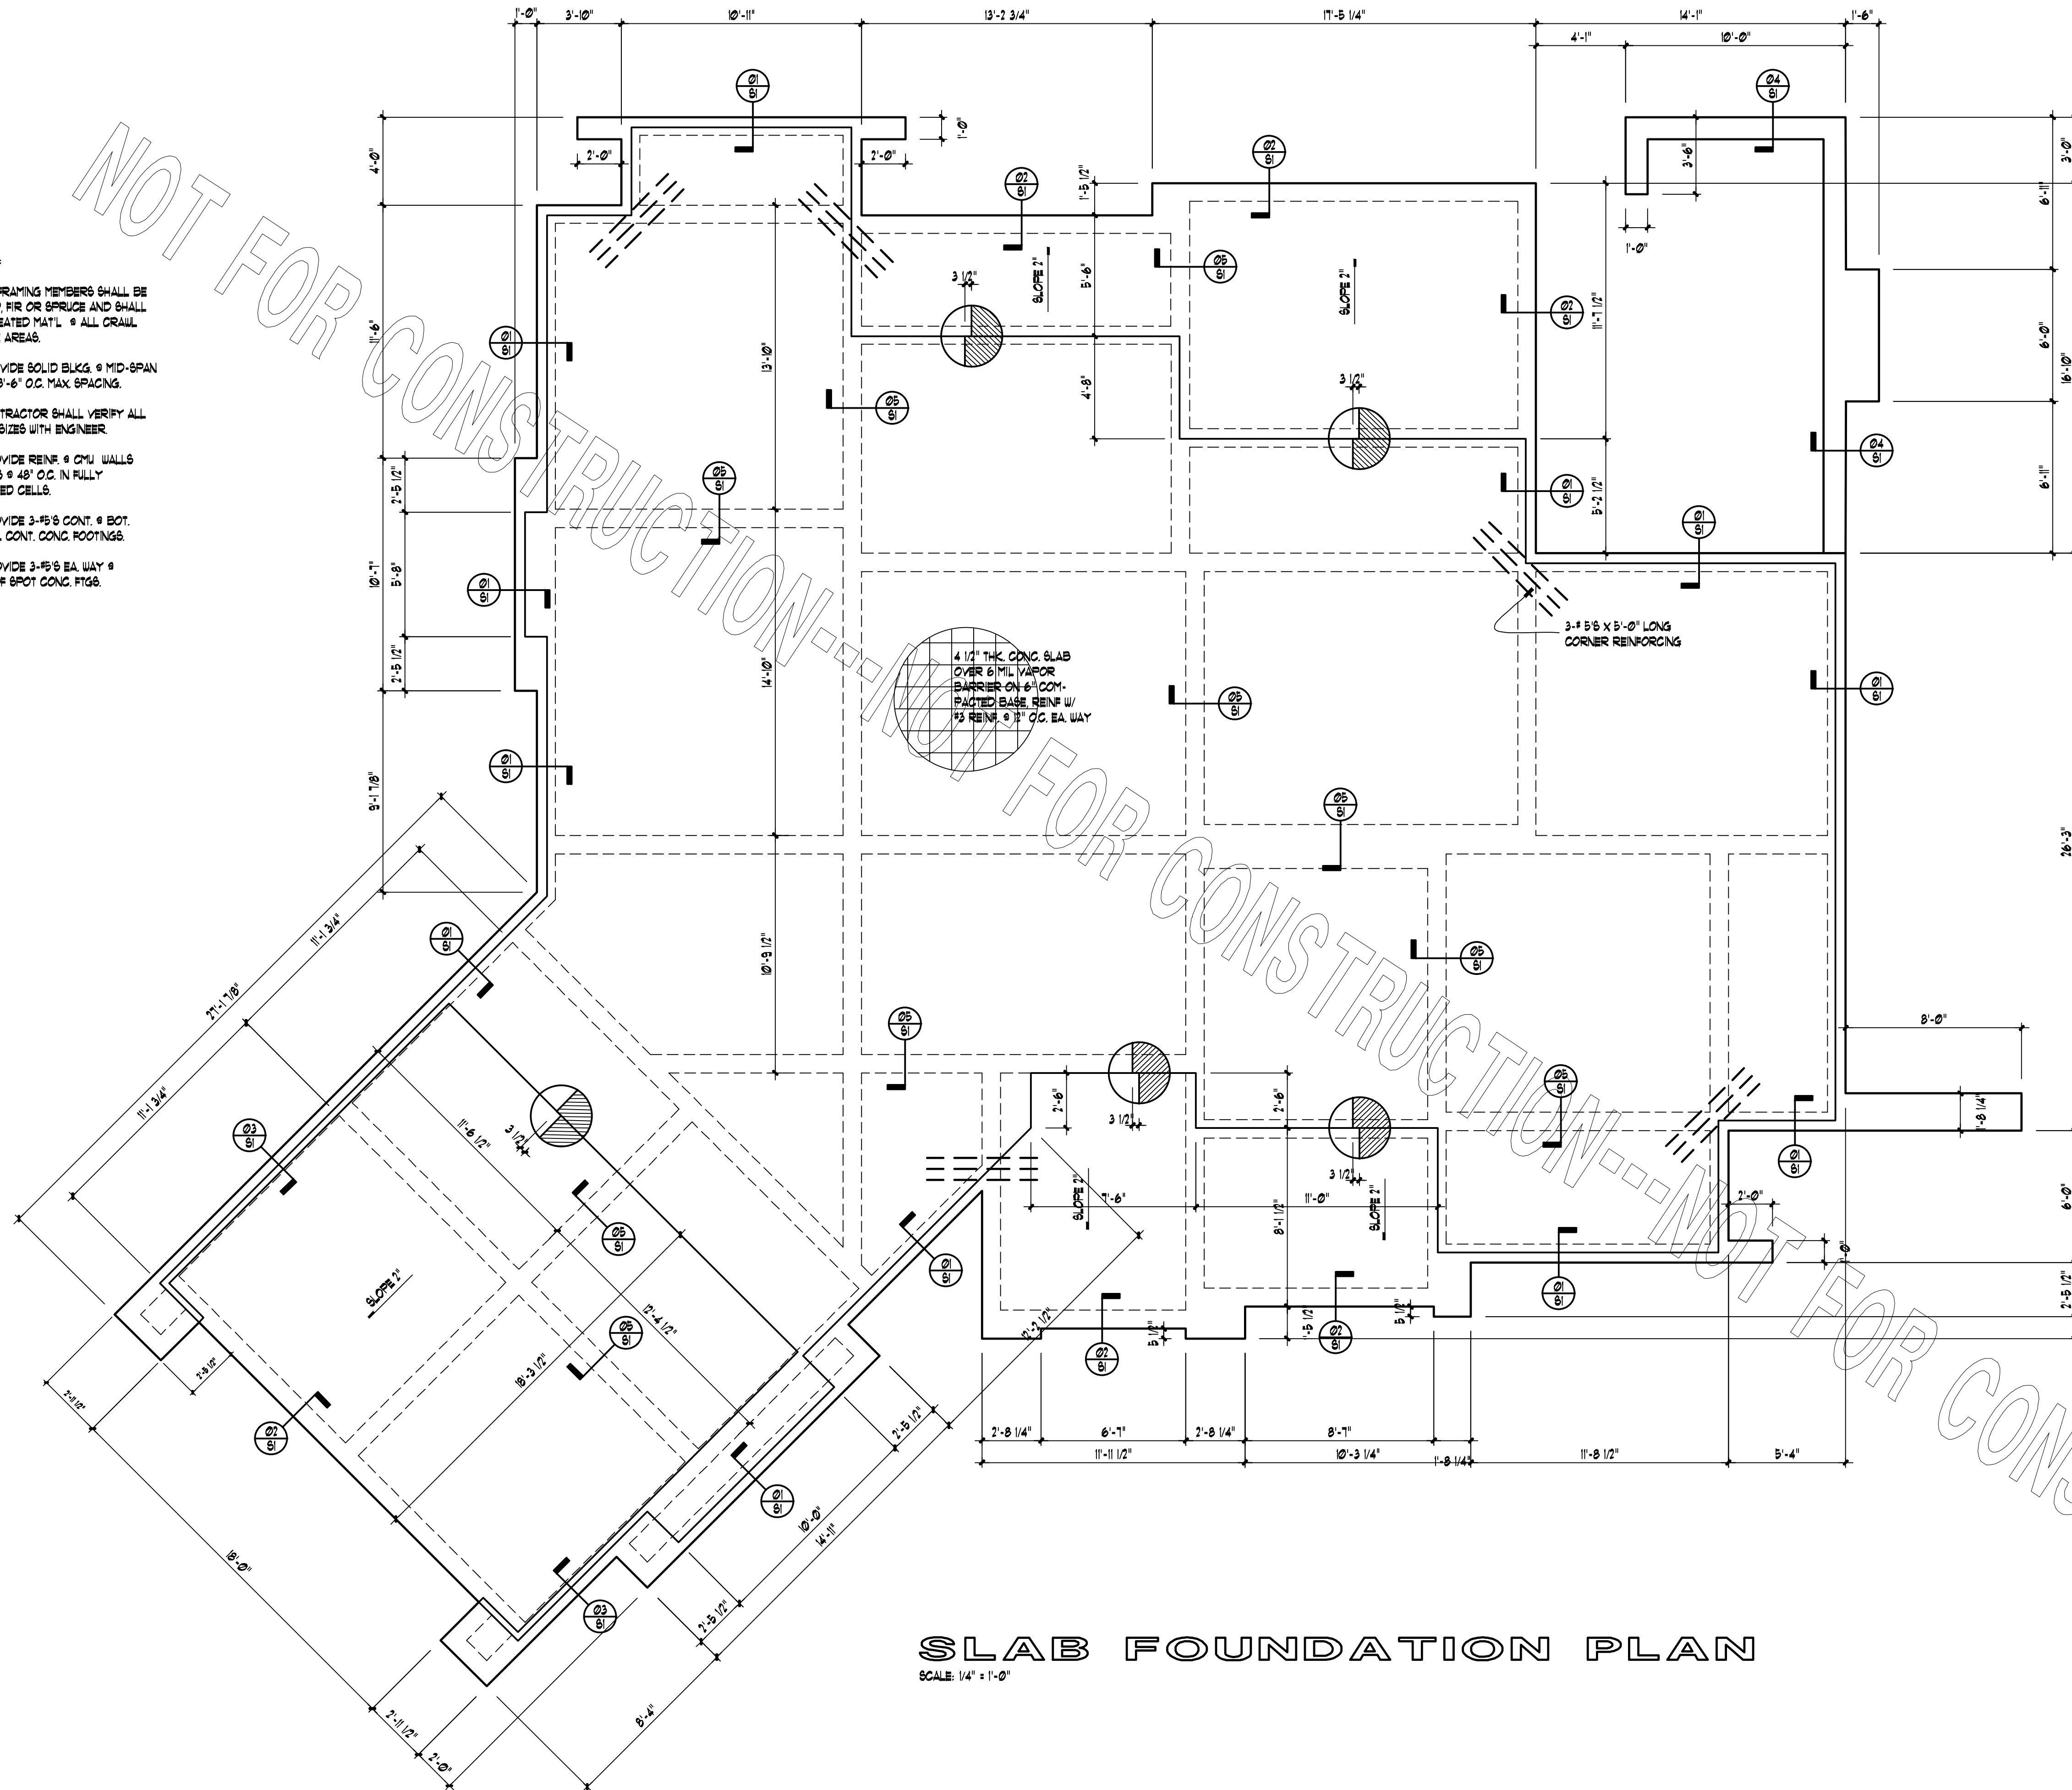


SLAB FOUNDATION PLAN

 SCALE: 1/4" = 1'-0"

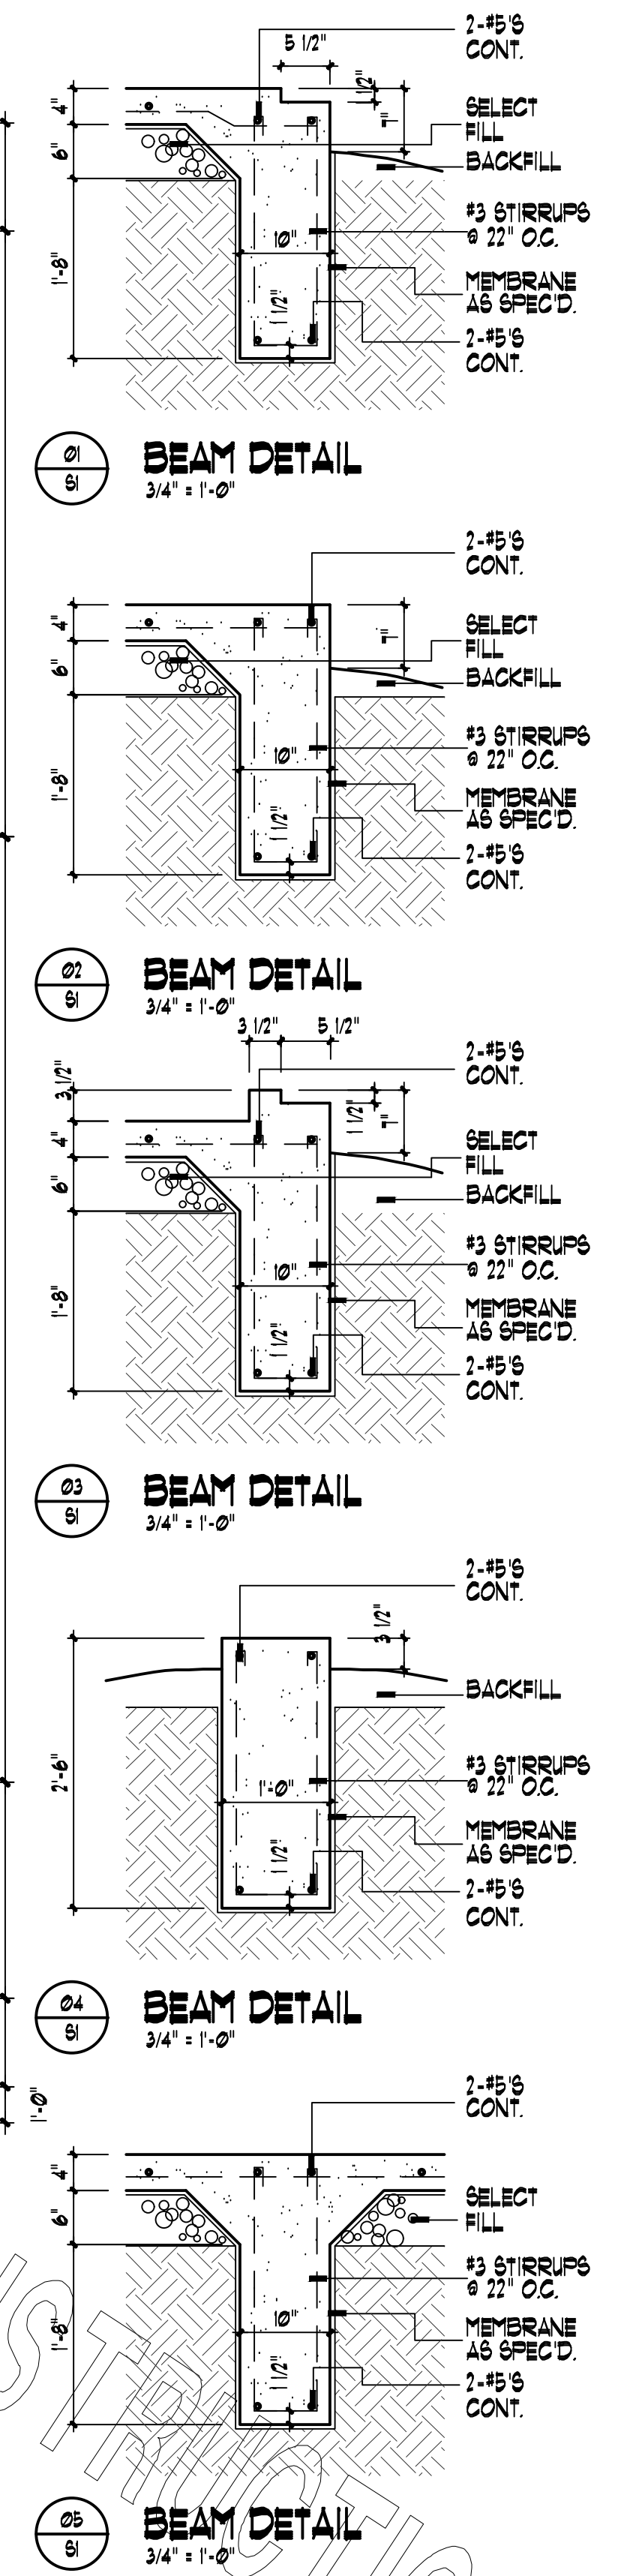

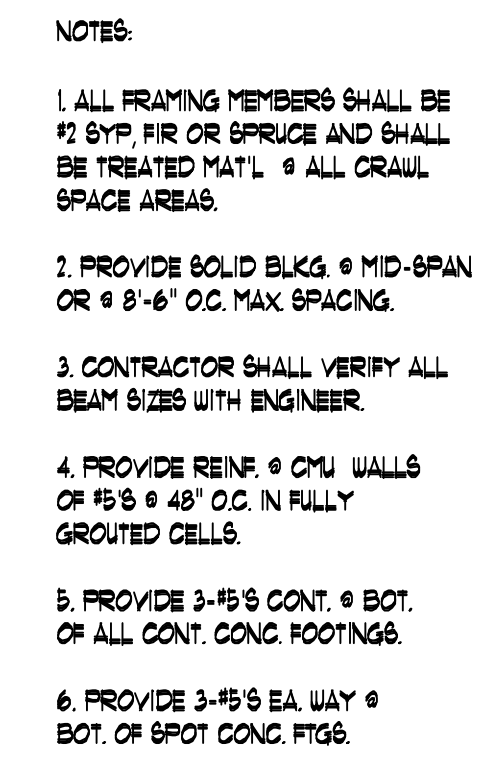

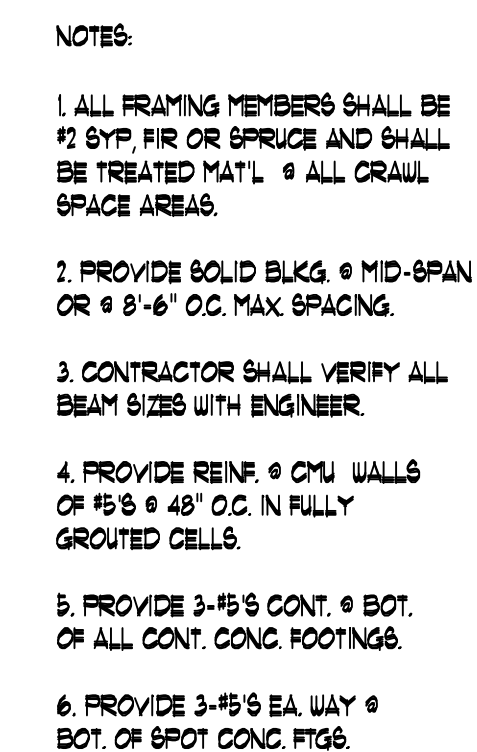

BASEMENT FRAMING PLAN